


West Linn-Wilsonville School District

New Athey Creek Middle School

Project Address to be determined.
Tax Lots 21E34C00600, 21E34DC00900, and 21E34DC01001
West Linn, OR 97068

VICINITY MAP

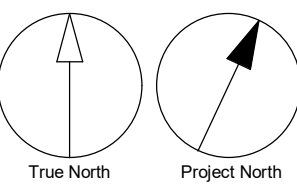

SHEET INDEX

GENERAL

LU0.00 COVER SHEET

CIVIL

LU1.000 OVERALL SITE ANALYSIS LAND TYPES
LU1.00 OVERALL SITE ANALYSIS
LU1.01 SITE ANALYSIS
LU1.02 SITE ANALYSIS
LU1.03 SITE ANALYSIS
LU1.04 SITE ANALYSIS
LU1.05 SITE ANALYSIS
LU1.06 SITE ANALYSIS
LU1.07 SITE ANALYSIS

LU1.10 OVERALL SITE PLAN
LU1.11 SITE PLAN
LU1.12 SITE PLAN
LU1.13 SITE PLAN
LU1.14 SITE PLAN
LU1.15 SITE PLAN
LU1.16 SITE PLAN
LU1.17 SITE PLAN

LU1.20 OVERALL GRADING AND DRAINAGE PLAN
LU1.21 GRADING AND DRAINAGE PLAN
LU1.22 GRADING AND DRAINAGE PLAN
LU1.23 GRADING AND DRAINAGE PLAN
LU1.24 GRADING AND DRAINAGE PLAN
LU1.25 GRADING AND DRAINAGE PLAN
LU1.26 GRADING AND DRAINAGE PLAN
LU1.27 GRADING AND DRAINAGE PLAN

LU1.30 OVERALL UTILITY PLAN
LU1.31 UTILITY PLAN
LU1.32 UTILITY PLAN
LU1.33 UTILITY PLAN
LU1.34 UTILITY PLAN
LU1.35 UTILITY PLAN
LU1.36 UTILITY PLAN
LU1.37 UTILITY PLAN

LANDSCAPE

L1001 TREE PROTECTION PLAN
L1002 TREE PROTECTION PLAN

L1100 MATERIALS PLAN OVERALL
L1101 MATERIALS PLAN
L1102 MATERIALS PLAN
L1103 MATERIALS PLAN
L1104 MATERIALS PLAN
L1105 MATERIALS PLAN
L1106 MATERIALS PLAN
L1107 MATERIALS PLAN

L1400A PLANTING PLAN OVERALL
L1400B PLANTING SCHEDULE

L1401 PLANTING PLAN
L1402 PLANTING PLAN
L1403 PLANTING PLAN
L1404 PLANTING PLAN
L1405 PLANTING PLAN
L1406 PLANTING PLAN
L1407 PLANTING PLAN

ARCHITECTURAL

LU3.01 FLOOR PLAN LEVEL 01
LU3.02 FLOOR PLAN LEVEL 02
LU3.03 EXTERIOR ELEVATIONS
LU3.04 BUILDING SECTIONS & SITE PLAN
LU3.05 PV CANOPIES & SITE PLAN
LU3.06 MONUMENT AND BUILDING SIGNAGE
LU3.07 EXTERIOR MATERIALS

ONSITE LIGHTING

LU4.01 LIGHT COVERAGE PLAN

OFFSITE LIGHTING

LU4.01 ILLUMINATION LEGEND
LU4.02 ILLUMINATION PLAN
LU4.03 ILLUMINATION PLAN
LU4.04 ILLUMINATION PLAN
LU4.05 ILLUMINATION PLAN
LU4.06 ILLUMINATION PLAN

EASEMENTS

E-1 EASEMENT MAP
E-2 EASEMENT MAP

West Linn-Wilsonville
School District




22210 SW Stafford Rd, Tualatin, OR 97062

| ISSUES | | |
|--------|-------------|------------|
| No. | DESCRIPTION | DATE |
| A | LAND USE | 2021-03-17 |

New Athey Creek Middle School

Project Address to be determined.
Tax Lots 21E34C00600, 21E34DC00900, and 21E34DC01001
West Linn, OR 97068

NOT FOR CONSTRUCTION

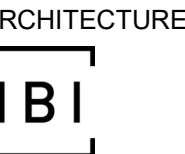

IBI GROUP
907 SW Harvey Milk Street
Portland, Oregon 97205
NAME: Jim Fitzpatrick
EMAIL: jim.fitzpatrick@ibigroup.com
PHONE: (503) 226-6950



KPFF CONSULTING
111 SE Fifth Avenue, Suite 2500,
Portland, Oregon 97204
NAME: Mark Wharry
EMAIL: mark.wharry@kpff.com
PHONE: (503) 542 3860



WALKER MACY
111 SW 5th Street, Suite 200
Portland, Oregon 97204
NAME: Mike Zilis
EMAIL: mizilis@walkermacy.com
PHONE: (503) 228 3122



KPFF CONSULTING
111 SE Fifth Avenue, Suite 2500
Portland, Oregon 9704
NAME: Jerry Abdie
EMAIL: jerry.abdie@kpff.com
PHONE: (503) 227 3251



PAE Engineers
522 SW 5th Avenue, Suite 1500
Portland, Oregon 97204
NAME: Nick Collins
EMAIL: nick.collins@pae-engineers.com
PHONE: (503) 226-2921



VERTEX TECHNOLOGY DESIGN & CONSULTING
NAME: Darcy Tucker
EMAIL: darcy@vertex-tech.com
PHONE: (503) 201-6568



HALLIDAY ASSOCIATES
656 Northwest Norwood St
Camas WA 98607
NAME: Laura Bourland
EMAIL: Laura@haldesign.com
PHONE: (360) 834-6657



PLA
285 NE Elam Young Pkwy, Ste B500
Hillsboro, OR 97124
NAME: Paul Luntsford
EMAIL: Paul@pladesigns.com
PHONE: (503) 642 2168



LISTEN ACOUSTICS
4949 S Macadam Ave, Suite 22
Portland, Oregon 97204
NAME: Tobin Cooley
EMAIL: tobin@listenacoustics.com
PHONE: (503) 241-5255



PROFESSIONAL ROOF CONSULTANTS
1108 SE Grand Ave, Suite 300
Portland, Oregon 97214
NAME: Steven McBride
EMAIL: Steven.McBride@professionalroofconsultants.com
PHONE: (503) 280-8759



ACC COST CONSULTANTS
8000 SW Platte St, Suite 110
Tigard, Oregon 97223
NAME: Seth Pszczolkowski
EMAIL: sethp@archoost.com
PHONE: (503) 718 0075

PRIME CONSULTANT



IBI GROUP
907 SW Harvey Milk Street
Portland, OR 97205, USA
tel 503 226 6950 fax 503 273 9192
ibigroup@ibimr.com

PROJECT NO:

124738

DATE:

2021-03-17

SHEET NUMBER

LU0.00



| LEGEND | TOTAL SITE: 22.1 ACRES |
|-----------|-----------------------------------|
| [Pattern] | TYPE I LANDS (2.8 ACRES, 12.7%) |
| [Pattern] | TYPE II LANDS (0.9 ACRES, 4.1%) |
| [Pattern] | TYPE III LANDS (7.3 ACRES, 33.0%) |
| [Pattern] | TYPE IV LANDS (11.1 ACRES, 50.2%) |

CLIENT

West Linn-Wilsonville School District

22210 SW Stafford Rd, Tualatin, OR 97062

COPYRIGHT

This drawing has been prepared solely for the intended use, thus any reproduction or distribution for any purpose other than authorized by IBI Group is forbidden. Written dimensions shall have precedence over scaled dimensions. Contractors shall verify and be responsible for all dimensions and conditions on the job, and IBI Group shall not be held liable for any variations from the dimensions and conditions shown on the drawing. Shop drawings shall be submitted to IBI Group for general performance before proceeding with fabrication.

PLEASE CHOOSE LEGAL ENTITY

is a member of the IBI Group of companies

| ISSUES | No. | DESCRIPTION | DATE |
|--------|----------|-------------|------------|
| 1 | LAND USE | | 2021-03-17 |

KEYPLAN

CONSULTANTS

111 SW Fifth Ave., Suite 2600
Portland, OR 97204
P: 503.542.3860
F: 503.274.4681
www.kpff.com

SEAL

IBI GROUP

907 SW Harvey Milk Street
Portland, OR 97205, USA
tel 503 226 6950 fax 503 273 9192
ibi@group-edi.com

PROJECT

New Athey Creek Middle School

945 Dollar Street
West Linn, OR 97068

PROJECT NO:

124738

| | |
|--------------|--------------|
| DRAWN BY: | CHECKED BY: |
| XX | Checker |
| PROJECT MGR: | APPROVED BY: |
| Designer | Approver |

SHEET TITLE

OVERALL SITE ANALYSIS
LAND TYPES

| | |
|--------------|-------|
| SHEET NUMBER | ISSUE |
| LU1.000 | A |


File: N:\2020\20200903 Dollar Street\GIS\CAD\PLT\LU0000067-LU101-SITE-ANALYSIS.dwg TAB:LU1.01
Plotted: 3/16/21 at 4:20pm By: mmanter
2020-07-17 12:31:12 PM



LEGEND

- ≤10% SLOPE (11.3 ACRES, 51.1%)
- >10% to ≤25% SLOPE (7.9 ACRES, 35.8%)
- >25% to <35% SLOPE (1.3 ACRES, 5.9%)
- ≥35% SLOPE (1.6 ACRES, 7.2%)
- HABITAT CONSERVATION AREAS ¹
- LANDSLIDE HAZARD AREAS, MAP 16 (2.6 ACRES)
- EARTHQUAKE HAZARD AREAS, MAP 17 (8.3 ACRES)
- WATER RESOURCE AREA BOUNDARY ¹
- STREAMS ¹
- EXISTING SURFACE FLOW DIRECTION
- EXISTING MAJOR CONTOUR
- EXISTING MINOR CONTOUR

¹ (REFER TO NATURAL RESOURCE REVIEW PERFORMED BY PACIFIC HABITAT SERVICES)

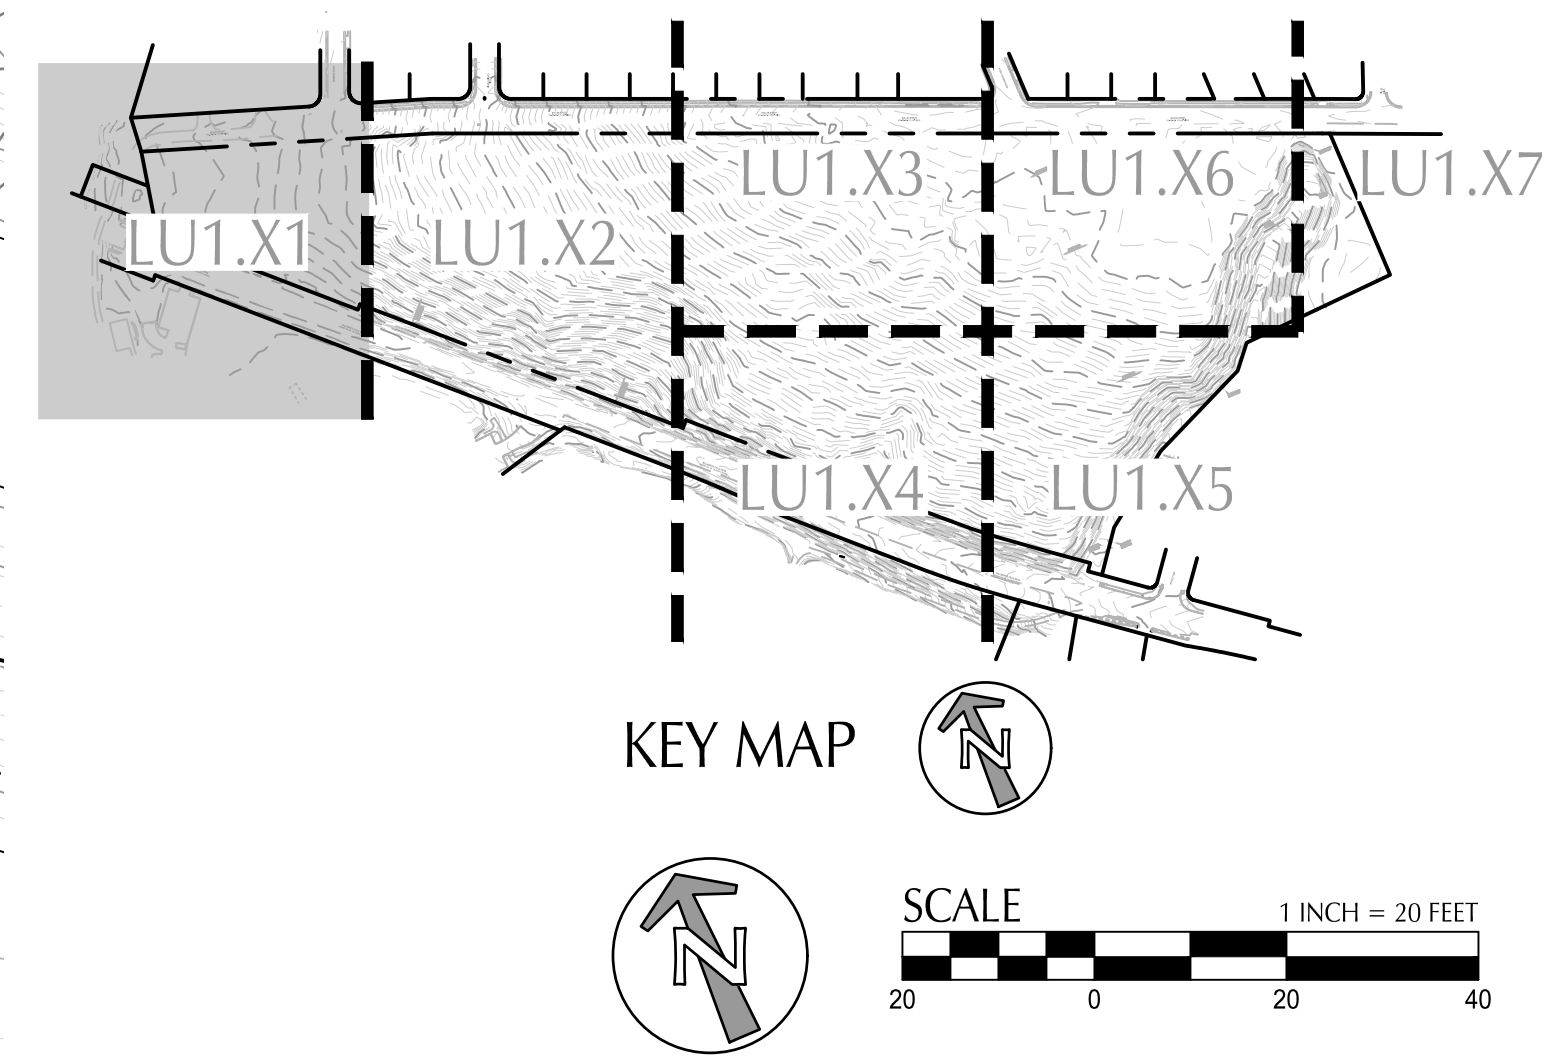

CLIENT

West Linn-Wilsonville School District

22210 SW Stafford Rd, Tualatin, OR 97062

COPYRIGHT
This drawing has been prepared solely for the intended use, and any reproduction or distribution for any purpose other than authorized by IBI Group is forbidden. Written dimensions shall have precedence over scaled dimensions. Contractors shall verify and be responsible for all dimensions and conditions on the job, and IBI Group shall not be liable for any variations from the dimensions and conditions shown on the drawing. Shop drawings shall be submitted to IBI Group for general confirmation before proceeding with fabrication.

PLEASE CHOOSE LEGAL ENTITY
is a member of the IBI Group of companies

| ISSUES | | DATE |
|--------|-------------|------------|
| No. | DESCRIPTION | |
| 1 | LAND USE | 2021-03-17 |

KEYPLAN

CONSULTANTS

kpf

111 SW Fifth Ave., Suite 2600
Portland, OR 97204
P: 503.542.3860
F: 503.274.4681
www.kpf.com

SEAL

IBI GROUP
907 SW Harvey Milk Street
Portland, OR 97205, USA
tel 503 226 6950 fax 503 273 9192
ibi@group-egm.com

PROJECT
New Athey Creek Middle School
945 Dollar Street
West Linn, OR 97068

PROJECT NO:
124738

DRAWN BY:
XX

PROJECT MGR:
Designer



CHECKED BY:
Checker




 





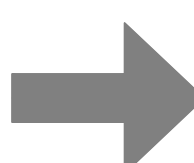


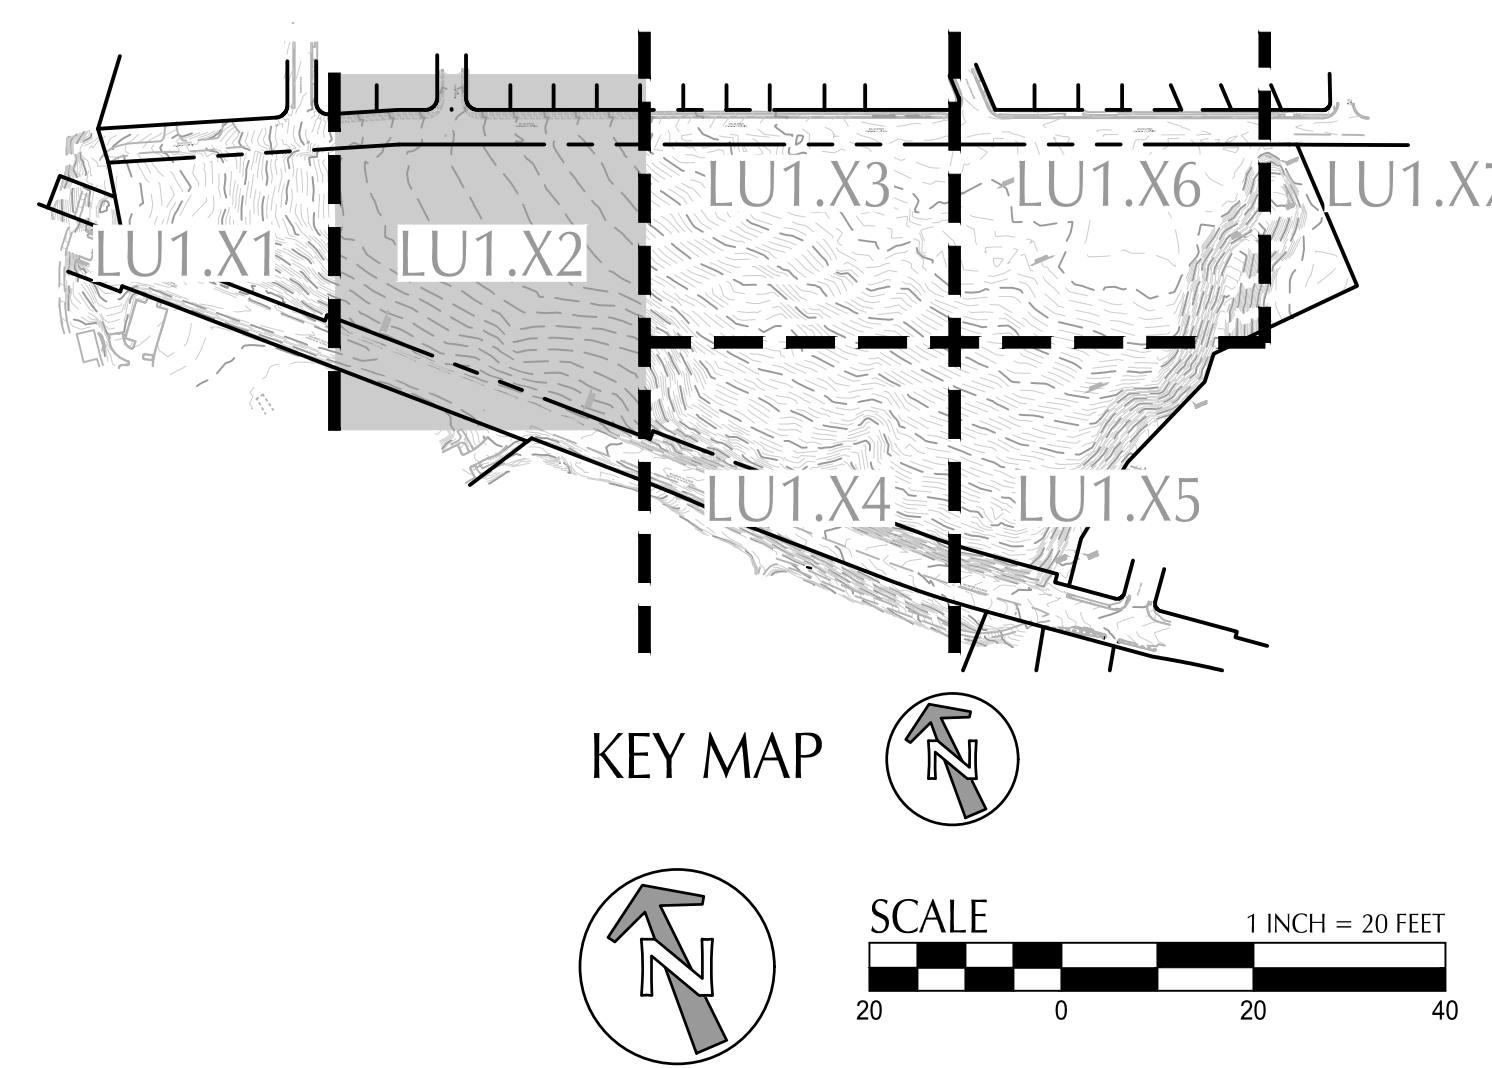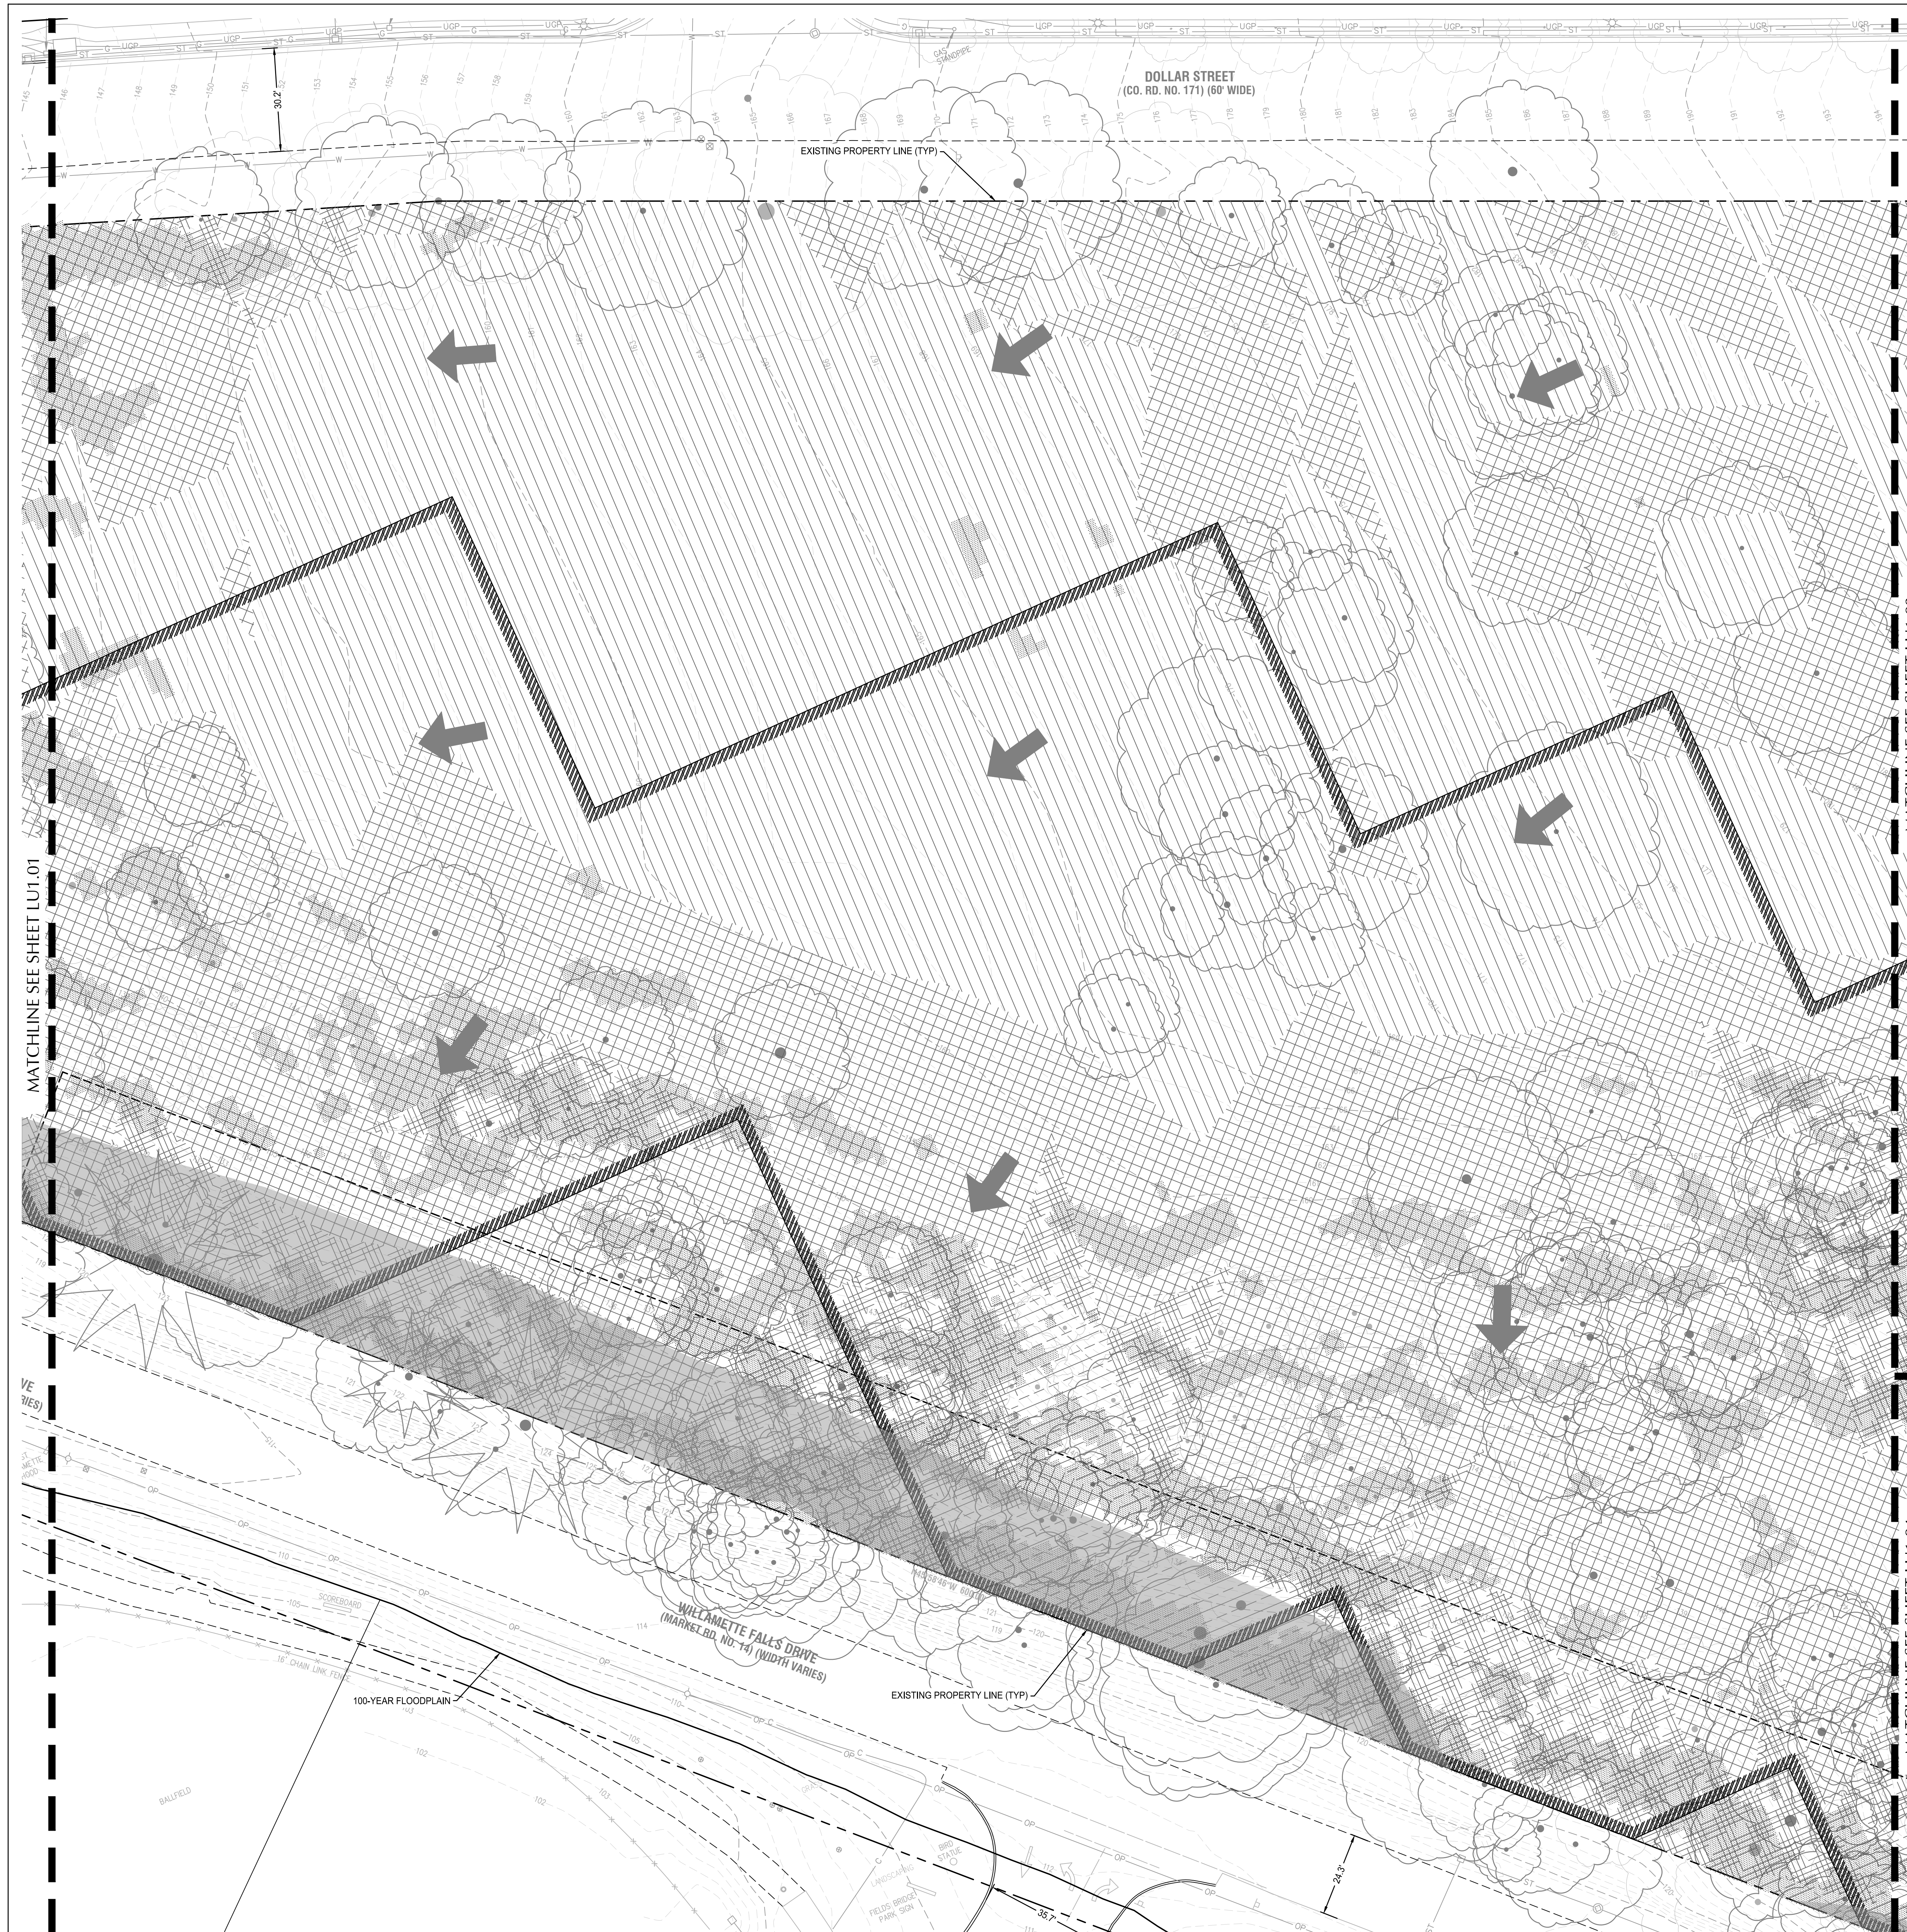APPROVED BY:
Approver



SHEET TITLE
SITE ANALYSIS

SHEET NUMBER
LU1.01

 











ISSUE
A

 


| LEGEND | | TOTAL SITE: 22.1 ACRES |
|---|---|------------------------|
|  | ≤10% SLOPE (11.3 ACRES, 51.1%) | |
|  | >10% to ≤25% SLOPE (7.9 ACRES, 35.8%) | |
|  | >25% to <35% SLOPE (1.3 ACRES, 5.9%) | |
|  | ≥35% SLOPE (1.6 ACRES, 7.2%) | |
|  | HABITAT CONSERVATION AREAS ¹ | |
|  | LANDSLIDE HAZARD AREAS, MAP 16 (2.6 ACRES) | |
|  | EARTHQUAKE HAZARD AREAS, MAP 17 (8.3 ACRES) | |
|  | WATER RESOURCE AREA BOUNDARY ¹ | |
|  | STREAMS ¹ | |
|  | EXISTING SURFACE FLOW DIRECTION | |
|  | EXISTING MAJOR CONTOUR | |
|  | EXISTING MINOR CONTOUR | |
| ¹ (REFER TO NATURAL RESOURCE REVIEW PERFORMED BY PACIFIC HABITAT SERVICES) | | |

| | | |
|--|--------------------------|------------|
| CLIENT | | |
| West Linn-Wilsonville School District | | |
|  | | |
| 22210 SW Stafford Rd, Tualatin, OR 97062 | | |
| COPYRIGHT | | |
| <small>This drawing has been prepared solely for the intended use. Thus, any reproduction or distribution for any purpose other than authorized by IBI Group is forbidden. Written dimensions shall have precedence over scaled dimensions. Contractors shall verify and be responsible for all dimensions and conditions on the job, and IBI Group shall be relieved of any liability from the dimensions and conditions shown on the drawing. Group drawings shall be submitted to IBI Group for general conformance before proceeding with fabrication.</small> | | |
| PLEASE CHOOSE LEGAL ENTITY | | |
| <small>is a member of the IBI Group of companies</small> | | |
| ISSUES | | |
| No. | DESCRIPTION | DATE |
| 1 | LAND USE | 2021-03-17 |
| | | |
| KEYPLAN | | |
| | | |
| CONSULTANTS | | |
|  | | |
| 111 SW Fifth Ave., Suite 2600 Portland, OR 97204 O: 503.542.3860 F: 503.274.4681 www.kpff.com | | |
| SEAL | | |
| | | |
| PROJECT | | |
| New Athey Creek Middle School | | |
| 945 Dollar Street West Linn, OR 97068 | | |
| PROJECT NO: 124738 | | |
| DRAWN BY: XX | CHECKED BY: Checker | |
| PROJECT MGR: Designer | APPROVED BY: Approver | |
| SHEET TITLE | | |
| SITE ANALYSIS | | |
| SHEET NUMBER | | |
| LU1.02 | | |
| ISSUE | | |
| A | | |




| LEGEND | | TOTAL SITE: 22.1 ACRES |
|---|---|------------------------|
|  | ≤10% SLOPE (11.3 ACRES, 51.1%) | |
|  | >10% to ≤25% SLOPE (7.9 ACRES, 35.8%) | |
|  | >25% to <35% SLOPE (1.3 ACRES, 5.9%) | |
|  | ≥35% SLOPE (1.6 ACRES, 7.2%) | |
|  | HABITAT CONSERVATION AREAS ¹ | |
|  | LANDSLIDE HAZARD AREAS, MAP 16 (2.6 ACRES) | |
|  | EARTHQUAKE HAZARD AREAS, MAP 17 (8.3 ACRES) | |
|  | WATER RESOURCE AREA BOUNDARY ¹ | |
|  | STREAMS ¹ | |
|  | EXISTING SURFACE FLOW DIRECTION | |
|  | EXISTING MAJOR CONTOUR | |
|  | EXISTING MINOR CONTOUR | |
| ¹ (REFER TO NATURAL RESOURCE REVIEW PERFORMED BY PACIFIC HABITAT SERVICES) | | |

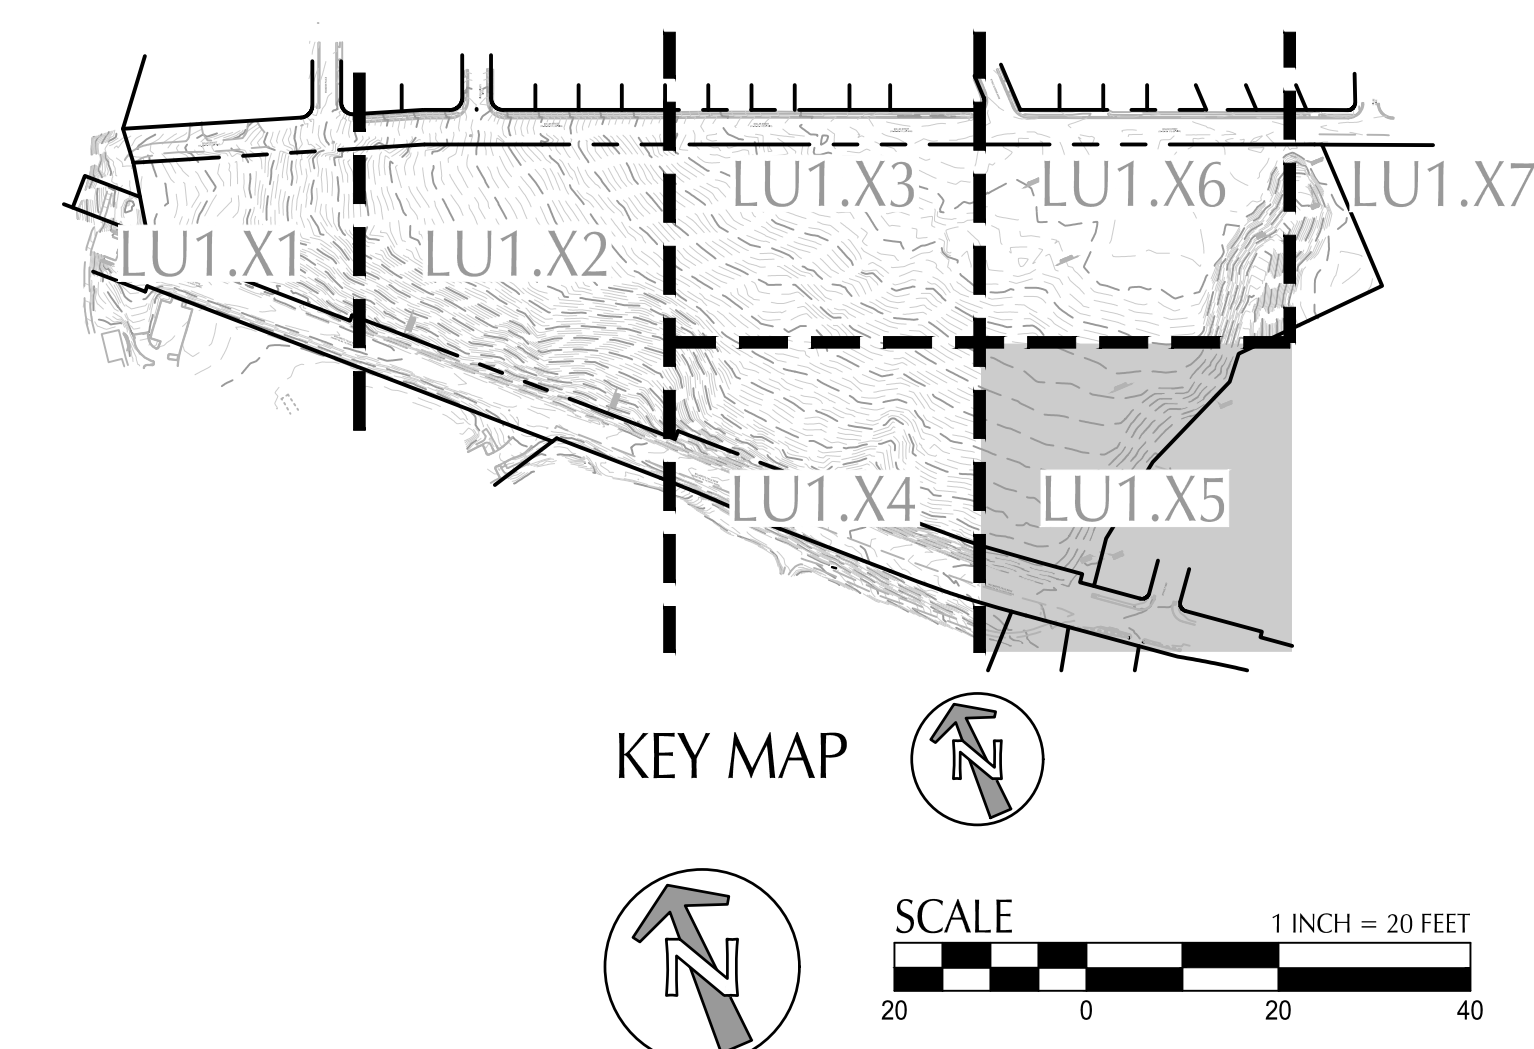

CLIENT

West Linn-Wilsonville School District



22210 SW Stafford Rd, Tualatin, OR 97062

COPYRIGHT

This drawing has been prepared solely for the intended use. Thus, any reproduction or distribution for any purpose other than authorized by IBI Group is forbidden. Written dimensions shall have precedence over scaled dimensions. Contractors shall verify and be responsible for all dimensions and conditions on the job, and IBI Group shall be relieved of any liabilities from the dimensions and conditions shown on the drawing. Shop drawings shall be submitted to IBI Group for general conformance before proceeding with fabrication.

PLEASE CHOOSE LEGAL ENTITY


is a member of the IBI Group of companies

ISSUES

| No. | DESCRIPTION | DATE |
|-----|-------------|------------|
| 1 | LAND USE | 2021-03-17 |

KEYPLAN

CONSULTANTS



111 SW Fifth Ave., Suite 2600


Portland, OR 97204

Q: 503.542.3860

F: 503.274.4681

www.kpff.com

SEAL



IBI GROUP

907 SW Harvey Milk Street

Portland, OR 97205, USA

tel 503 226 6950 fax 503 273 9192

ibi@group-edgww.com

PROJECT

New Athey Creek Middle School

945 Dollar Street

West Linn, OR 97068

PROJECT NO:

124738


| | |
|--------------|--------------|
| DRAWN BY: | CHECKED BY: |
| XX | Checker |
| PROJECT MGR: | APPROVED BY: |
| Designer | Approver |

SHEET TITLE

SITE ANALYSIS

| | |
|--------------|-------|
| SHEET NUMBER | ISSUE |
| LU1.05 | A |


File: N:\CUP\21-02 Staff Report\LU1.06-Site Analysis.dwg TAB: LU1.06
Plotter: 3/16/21 at 4:20pm By: mmaner
2023-07-17 12:31:12 PM

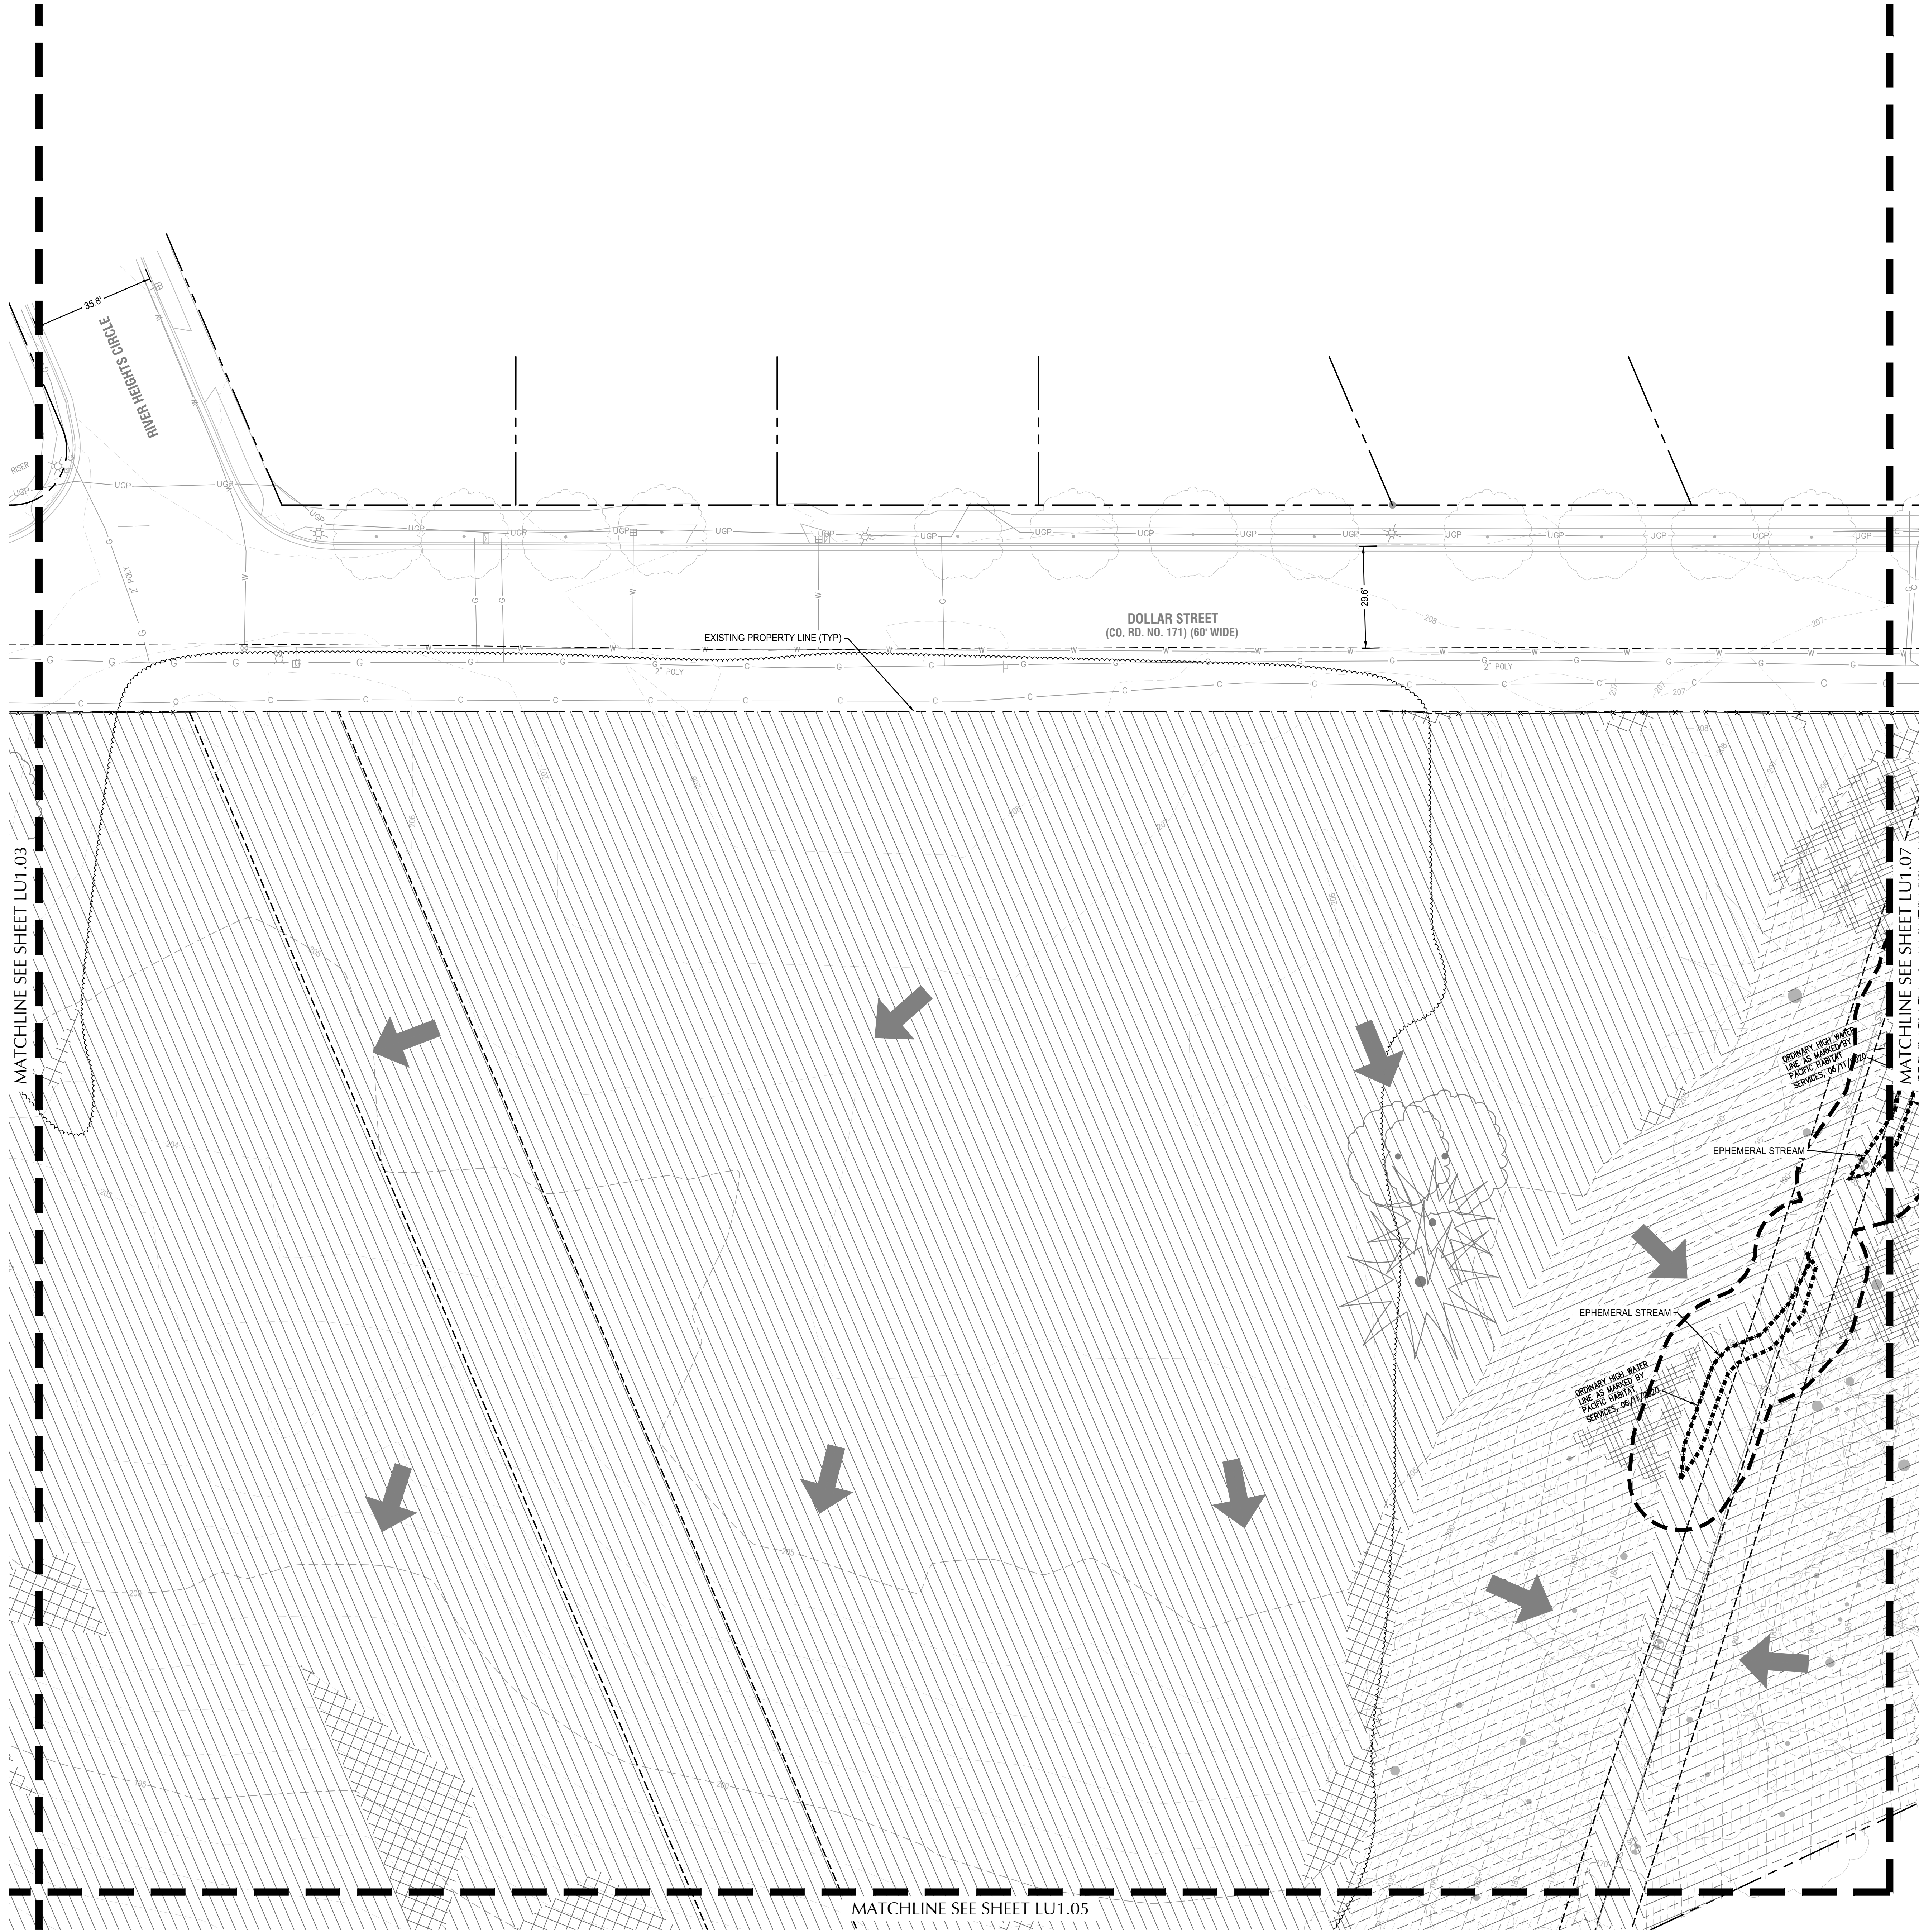

LEGEND

- ≤10% SLOPE (11.3 ACRES, 51.1%)
- >10% to ≤25% SLOPE (7.9 ACRES, 35.8%)
- >25% to <35% SLOPE (1.3 ACRES, 5.9%)
- ≥35% SLOPE (1.6 ACRES, 7.2%)
- HABITAT CONSERVATION AREAS ¹
- LANDSLIDE HAZARD AREAS, MAP 16 (2.6 ACRES)
- EARTHQUAKE HAZARD AREAS, MAP 17 (8.3 ACRES)
- WATER RESOURCE AREA BOUNDARY ¹
- STREAMS ¹
- EXISTING SURFACE FLOW DIRECTION
- EXISTING MAJOR CONTOUR
- EXISTING MINOR CONTOUR

¹ (REFER TO NATURAL RESOURCE REVIEW PERFORMED BY PACIFIC HABITAT SERVICES)

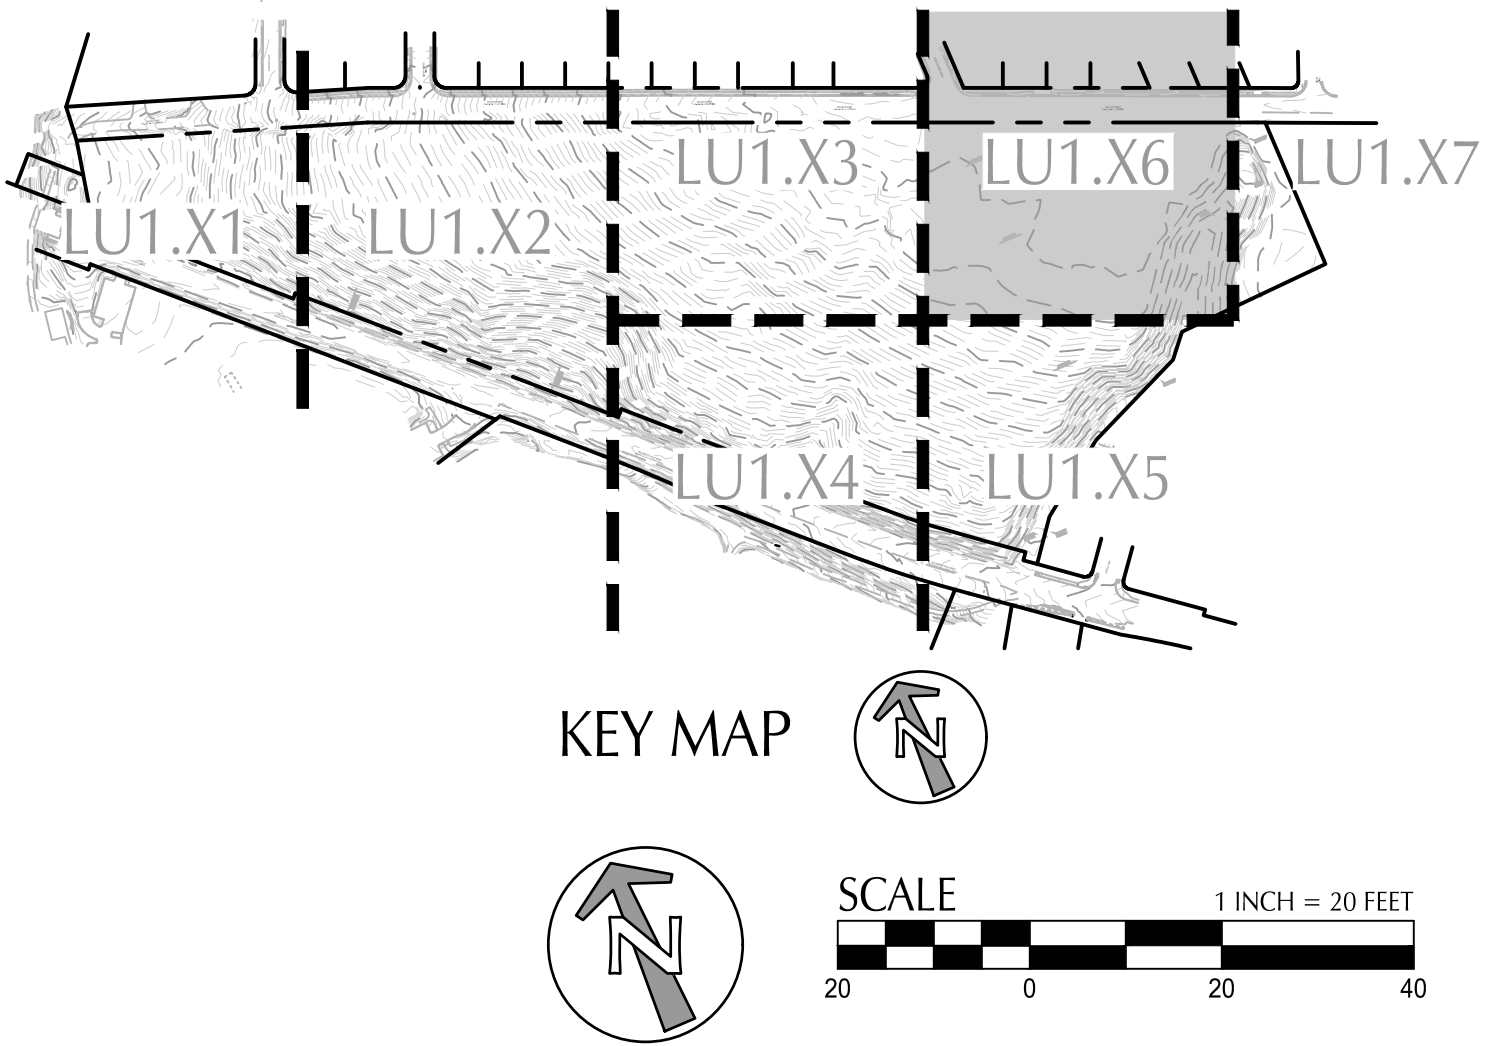

CLIENT
West Linn-Wilsonville School District
22210 SW Stafford Rd, Tualatin, OR 97062

COPYRIGHT
This drawing has been prepared solely for the intended use, thus any reproduction or distribution for any purpose other than authorized by IBI Group is forbidden. Neither IBI Group nor its consultants shall be responsible for any dimensions or conditions on the job, and IBI Group shall not be liable for any alterations made to the drawings and conditions shown on the drawing. Shop drawings shall be submitted to IBI Group for general review and approval before proceeding with fabrication.

PLEASE CHOOSE LEGAL ENTITY
is a member of the IBI Group of companies

| ISSUES | |
|--------|-------------|
| No. | DESCRIPTION |
| 1 | LAND USE |

KEYPLAN

CONSULTANTS

kpf
111 SW Fifth Ave., Suite 2600
Portland, OR 97204
P: 503.542.3860
F: 503.274.4681
www.kpf.com

SEAL

IBI GROUP
907 SW Harvey Milk Street
Portland, OR 97205, USA
tel 503 226 6950 fax 503 273 9192
ibi@group-ndg.com

PROJECT
New Athey Creek Middle School
945 Dollar Street
West Linn, OR 97068

PROJECT NO:
124738

DRAWN BY:
XX

CHECKED BY:
Checker


PROJECT MGR:
Designer

APPROVED BY:
Approver

SHEET TITLE
SITE ANALYSIS

SHEET NUMBER
LU1.06

ISSUE
A

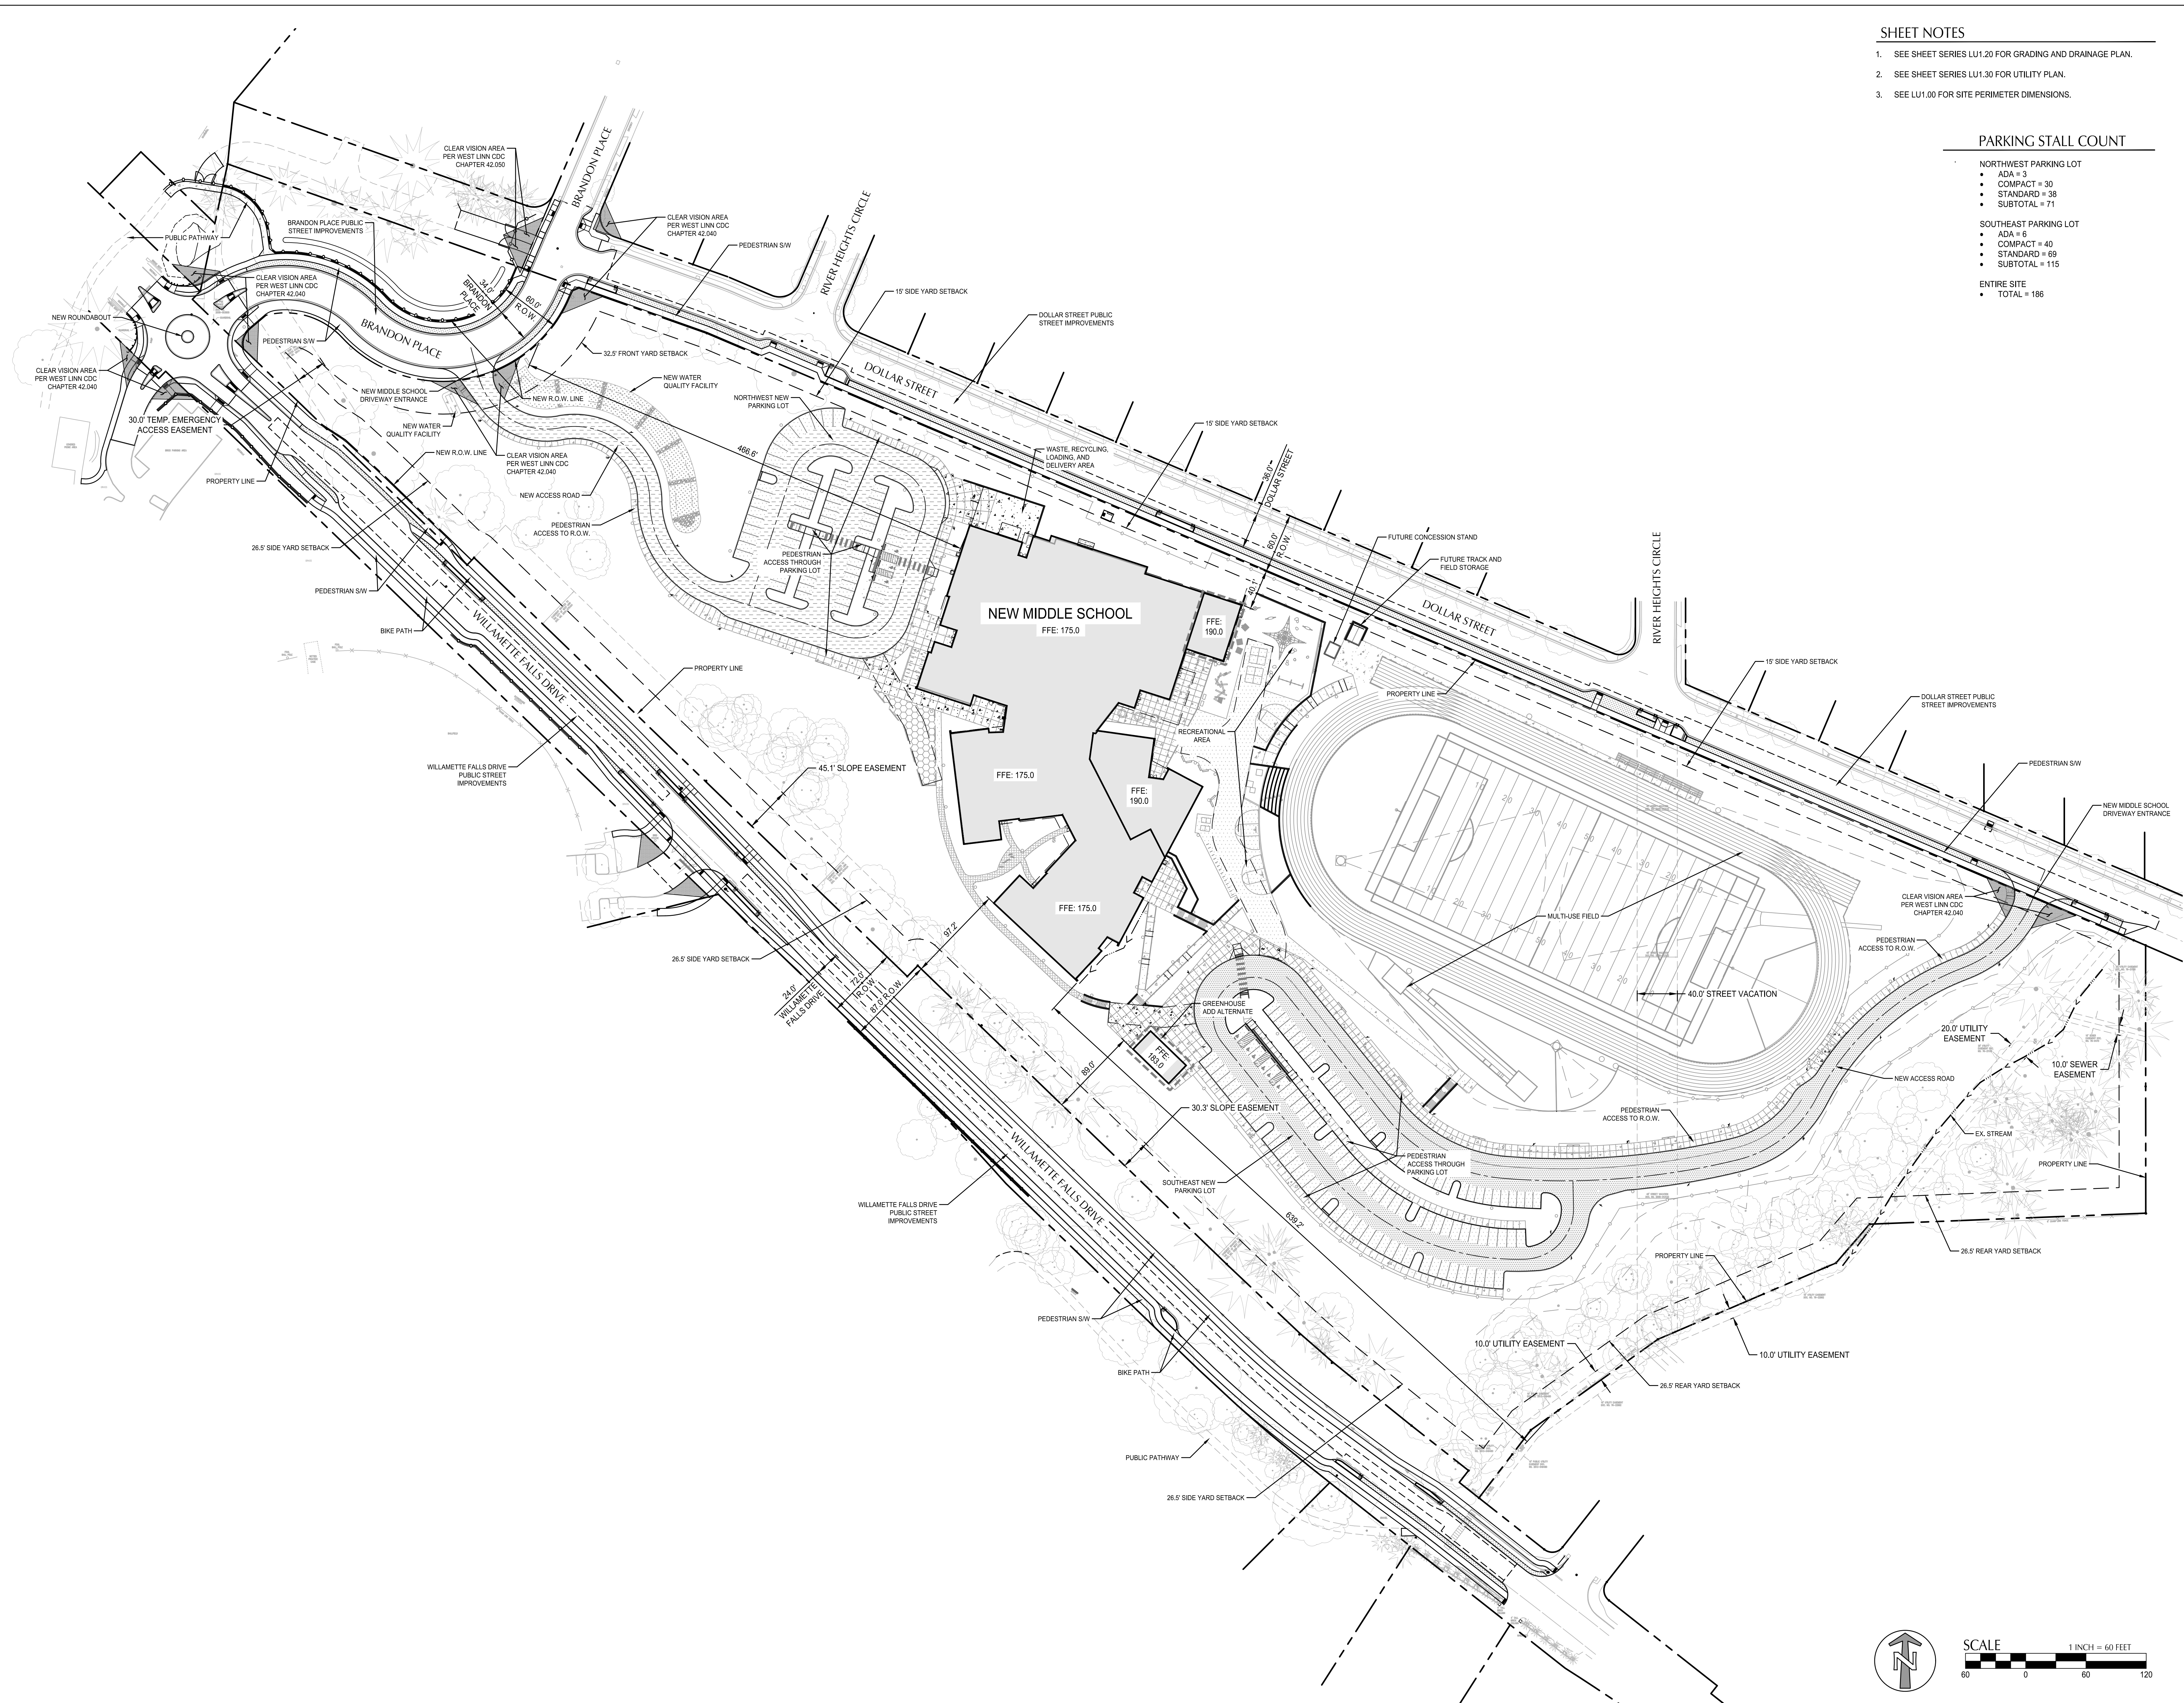

SHEET NOTES

PARKING STALL COUNT

- SOUTHEAST PARKING LOT
- ADA = 6
 - COMPACT = 40
 - STANDARD = 69
 - SUBTOTAL = 115

ENTIRE SITE
• TOTAL = 186

CLIENT



22210 SW Stafford Rd, Tualatin, OR 97062

PLEASE CHOOSE LEGAL ENTITY
Is a member of the BSA Council of companies

KEYPLAN



111 SW Fifth Ave., Suite 2600
Portland, OR 97204
O: 503.542.3860
F: 503.274.4681
www.kpff.com

SEAL

IBI GROUP
907 SW Harvey Milk Street
Portland, OR 97205, USA
tel 503 226 6950 fax 503 273 9192
ibigroup-edpnw.com

PROJECT
New Athey Creek Middle School

PROJECT NO:
124738

DRAWN BY:

PROJECT MO

Designer


SHEET TITLE
OVERALL SITE PLAN




SHEET NUMBER


LU1.10

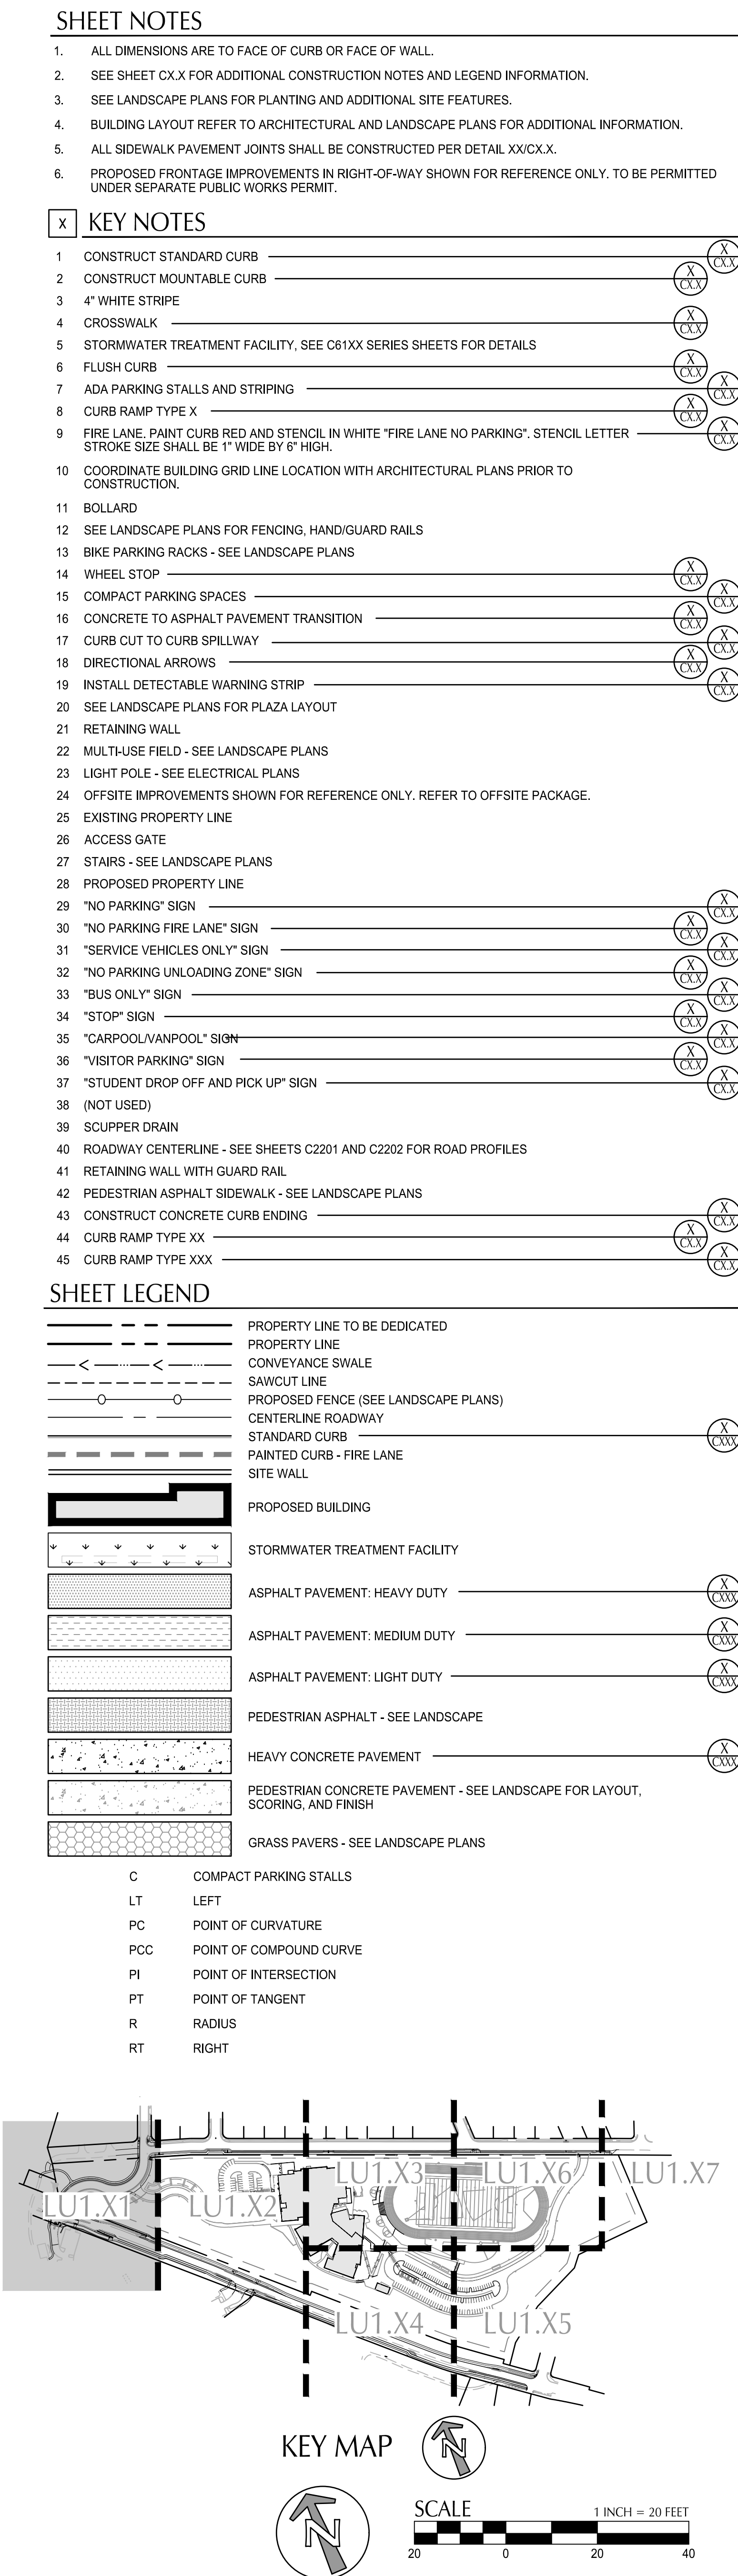


ISSUE

A

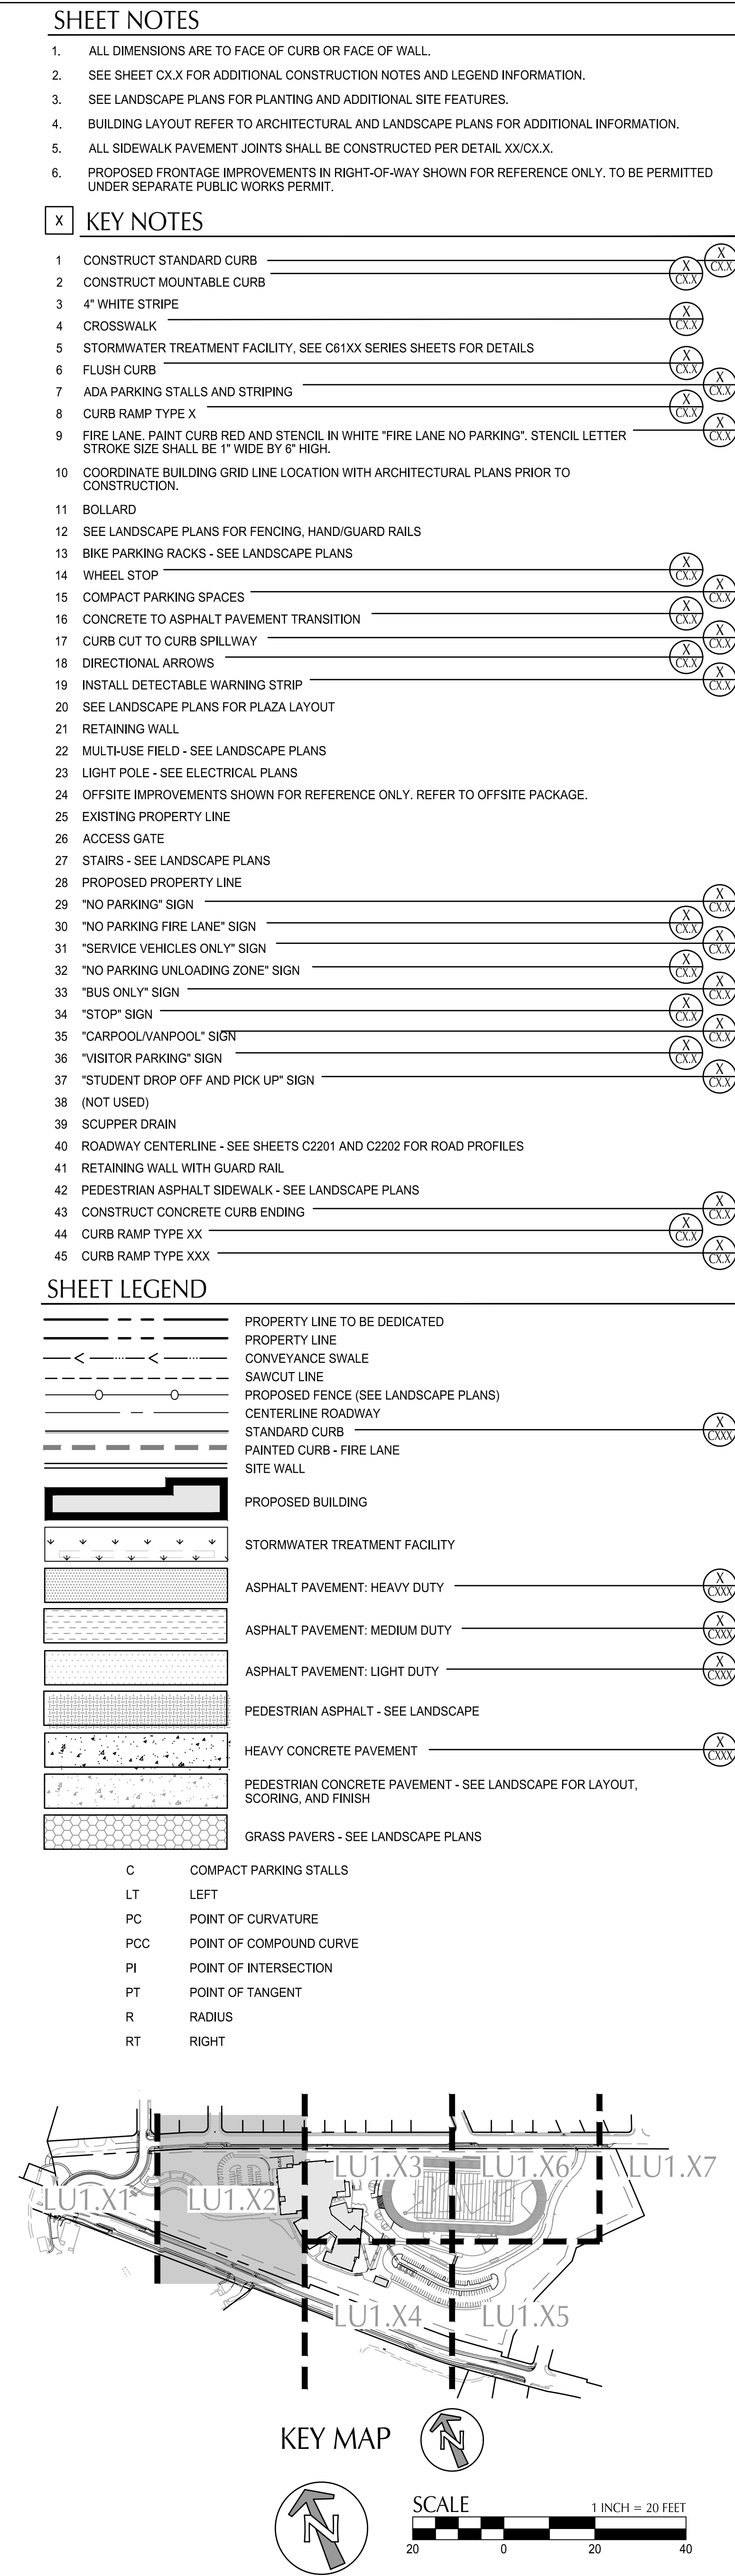


| | | |
|---|-------------|--------------------------|
| CLIENT <div>West Linn-Wilsonville School District</div> <div></div> <div>22210 SW Stafford Rd, Tualatin, OR 97062</div> | | |
| COPYRIGHT <div>This drawing has been prepared solely for the intended use, thus any reproduction or distribution for any purpose other than authorized by B2 Group is forbidden.</div> <div>Written dimensions shall have precedence over scaled dimensions. Contractors shall verify and be responsible for all dimensions and conditions on the job, and B2 Group shall be informed of any deviations from the dimensions and conditions shown on the drawing. Shop drawings shall be submitted to B2 Group for general confirmation before proceeding with fabrication.</div> | | |
| PLEASE CHOOSE LEGAL ENTITY <div>is a member of the B2 Group of companies</div> | | |
| ISSUES | | |
| No. | DESCRIPTION | DATE |
| 1 | LAND USE | 2021-03-17 |
| KEYPLAN | | |
| CONSULTANTS | | |
| <div></div> <div>111 SW Fifth Ave., Suite 2600 Portland, OR 97204 P: 503.542.3860 F: 503.274.4681 www.kpff.com</div> | | |
| SEAL | | |
| <div><div></div><div>IBI GROUP 907 SW Harvey Milk Street Portland, OR 97205, USA tel 503 226 6960 fax 503 273 9192 ibi@group-edinw.com</div></div> | | |
| PROJECT <div>New Athey Creek Middle School</div> <div>945 Dollar Street West Linn, OR 97068</div> | | |
| PROJECT NO: 124738 | | |
| DRAWN BY: XX | | CHECKED BY: Checker |
| PROJECT MGR: Designer | | APPROVED BY: Approver |
| SHEET TITLE <div>SITE PLAN</div> | | |
| SHEET NUMBER <div>LU1.11</div> | | ISSUE <div>A</div> |



| | | |
|--|--------------------------|----------------|
| CLIENT | | |
| West Linn-Wilsonville School District | | |
|  | | |
| 22210 SW Stafford Rd, Tualatin, OR 97062 | | |
| COPYRIGHT <small>This drawing has been prepared solely for the intended use. Thus any reproduction or distribution for any purpose other than authorized by BII Group is forbidden. Written dimensions shall have precedence over scaled dimensions. Contractors shall verify and be responsible for all dimensions and conditions on the job, and BII Group shall be relieved of any liabilities from the dimensions and conditions shown on this drawing. Group drawings shall be maintained in BII Group for general reference before proceeding with fabrication.</small> | | |
| PLEASE CHOOSE LEGAL ENTITY <small>is a member of the BII Group of Companies</small> | | |
| ISSUES | | |
| No. | DESCRIPTION | DATE |
| 1 | LAND USE | 2021-03-17 |
| KEYPLAN | | |
| CONSULTANTS | | |
|  111 SW Fifth Ave., Suite 2600 Portland, OR 97204 O: 503.542.3860 F: 503.274.4681 www.kpf.com | | |
| SEAL | | |
|  IBI GROUP 907 SW Harvey Milk Street Portland, OR 97205, USA tel 503 226 6950 fax 503 273 9192 ibi-group-edpnm.com | | |
| PROJECT New Athey Creek Middle School 945 Dollar Street West Linn, OR 97068 | | |
| PROJECT NO: 124738 | | |
| DRAWN BY: XX | CHECKED BY: Checker | |
| PROJECT MGR: Designer | APPROVED BY: Approver | |
| SHEET TITLE SITE PLAN | | |
| SHEET NUMBER LU1.12 | | ISSUE A |

File: N:\A\2020\09\09\093 Dwg: Sheet\A\ISCAD\PILOT\U0000067-LU11-SITE.dwg TAB: LU1.13
Plotted: 3/10/21 at 4:22pm By: mstaner
2020-07-17 12:31:12 PM

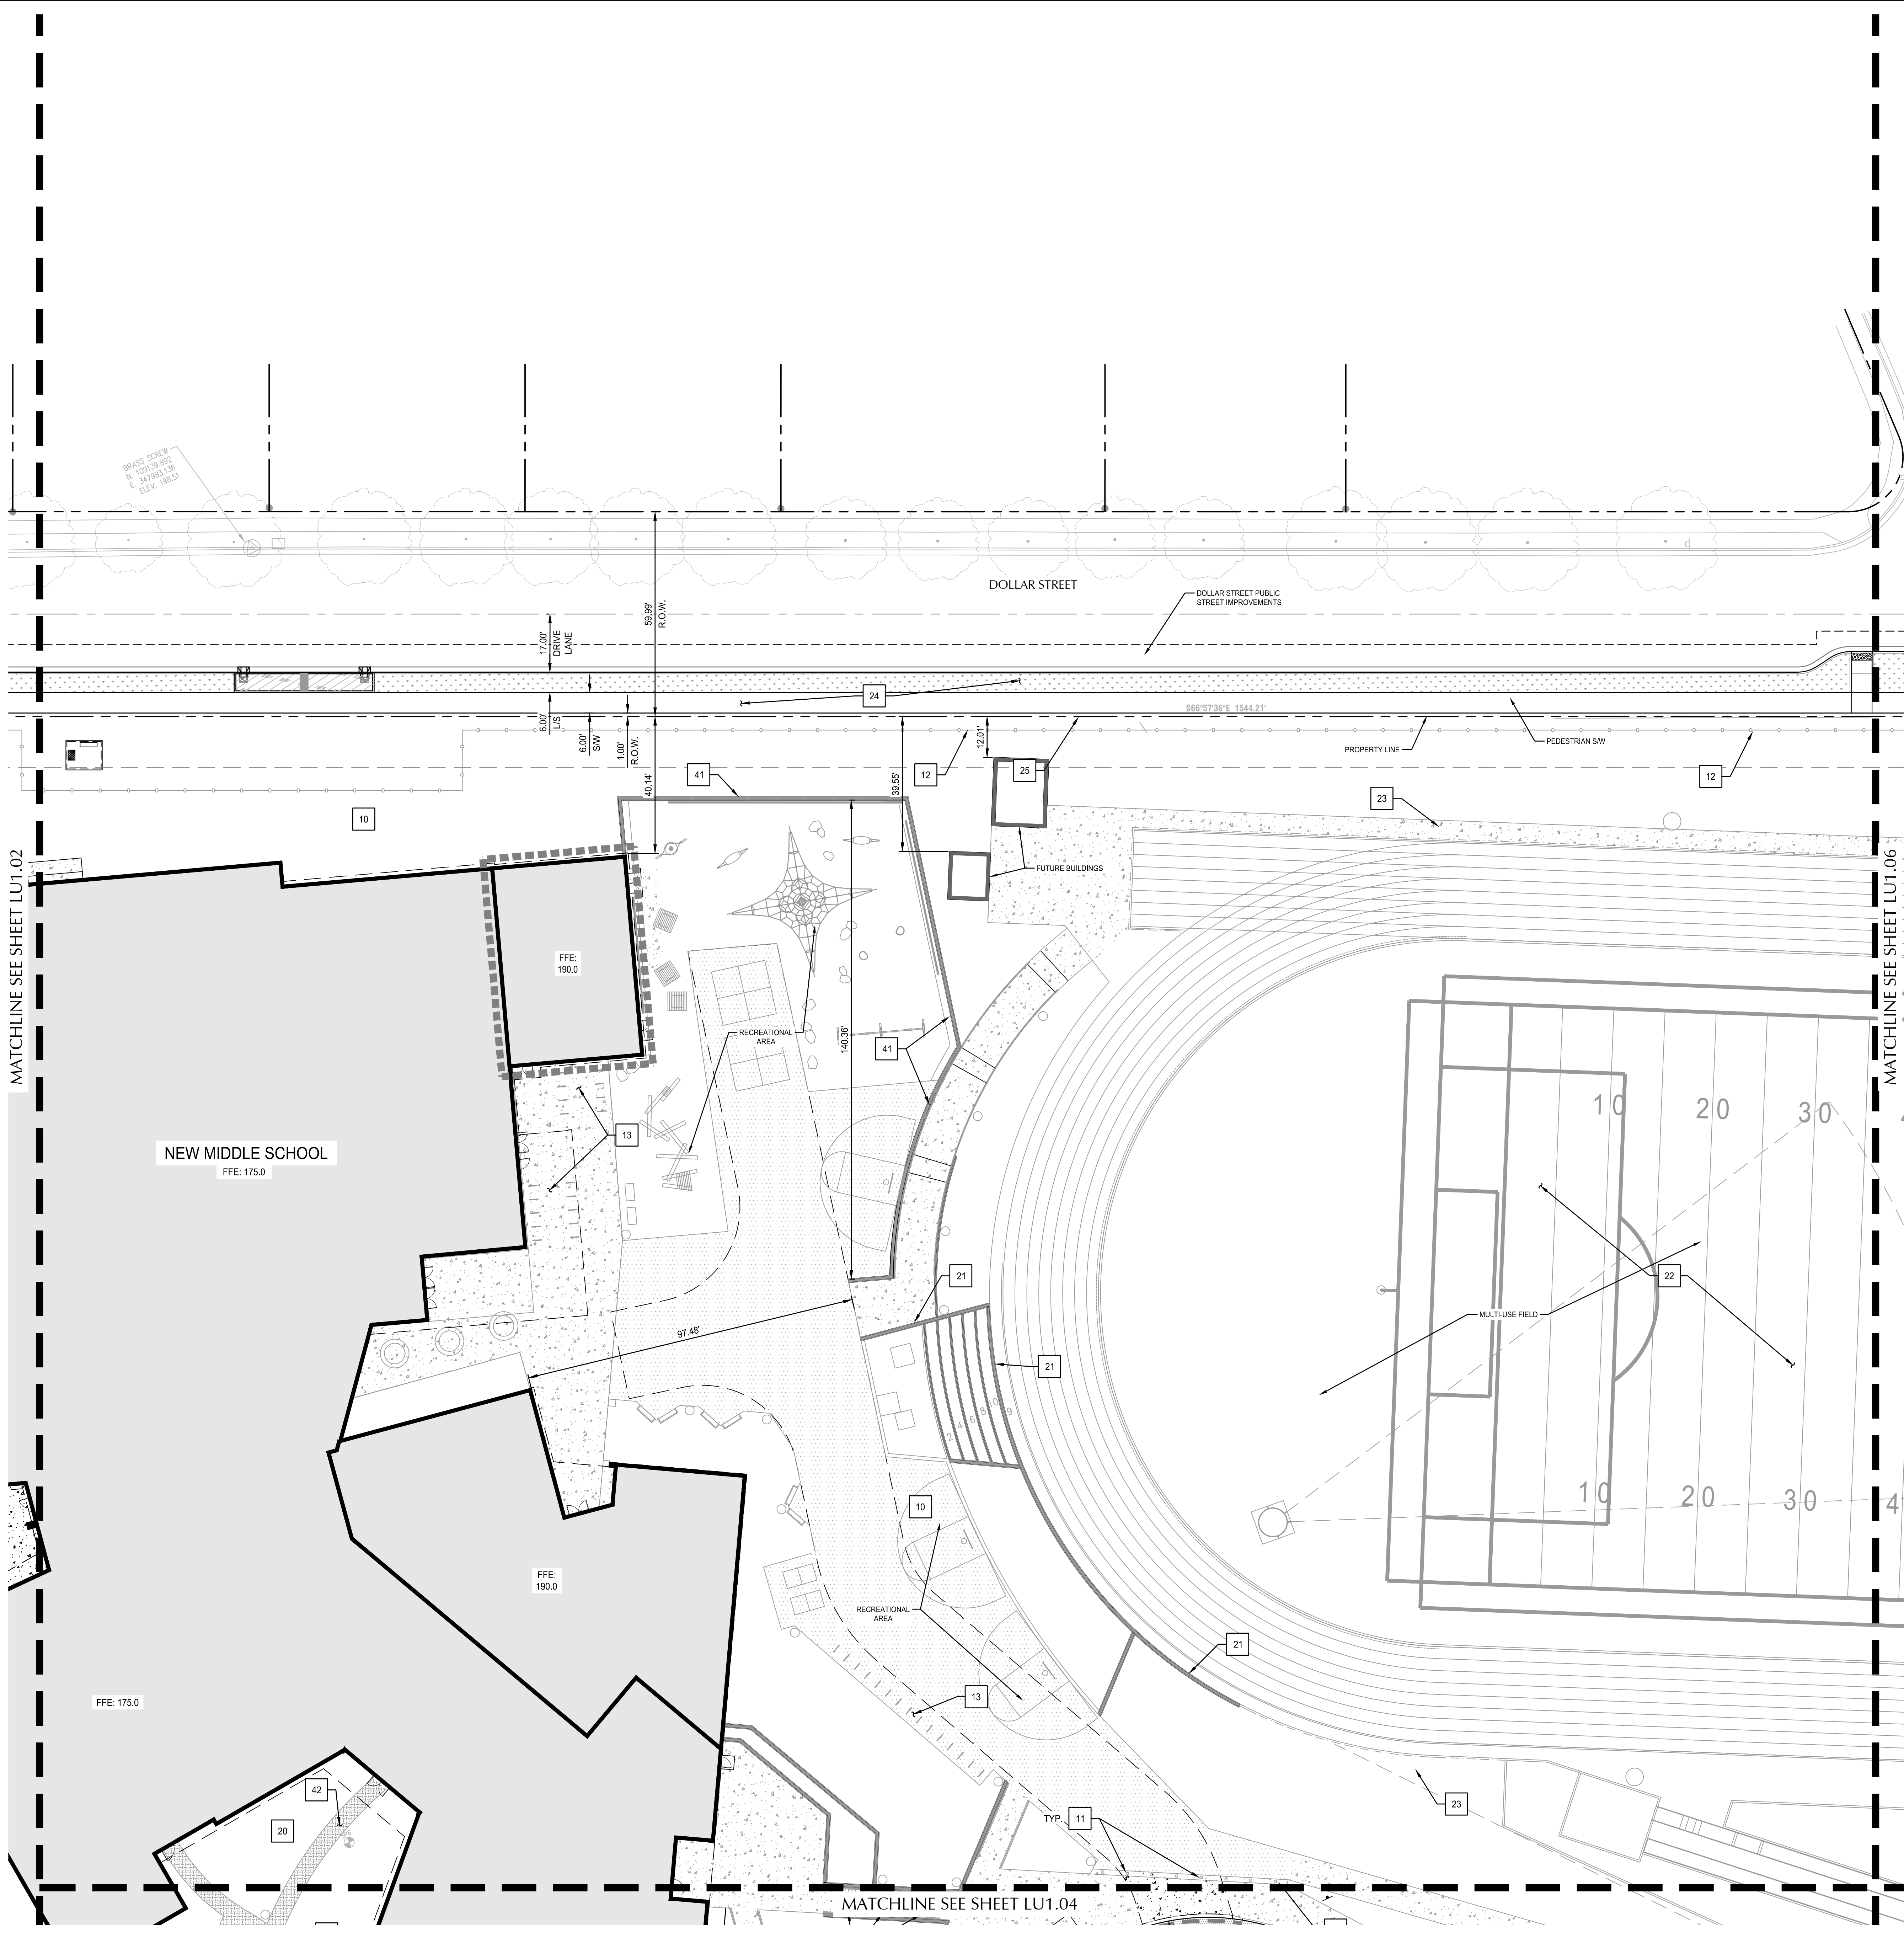

SHEET NOTES


1. ALL DIMENSIONS ARE TO FACE OF CURB OR FACE OF WALL.
2. SEE SHEET C.X.X FOR ADDITIONAL CONSTRUCTION NOTES AND LEGEND INFORMATION.
3. SEE LANDSCAPE PLANS FOR PLANTING AND ADDITIONAL SITE FEATURES.
4. BUILDING LAYOUT REFER TO ARCHITECTURAL AND LANDSCAPE PLANS FOR ADDITIONAL INFORMATION.
5. ALL SIDEWALK PAVEMENT JOINTS SHALL BE CONSTRUCTED PER DETAIL XX/C.X.
6. PROPOSED FRONTAGE IMPROVEMENTS IN RIGHT-OF-WAY SHOWN FOR REFERENCE ONLY. TO BE PERMITTED UNDER SEPARATE PUBLIC WORKS PERMIT.

X KEY NOTES


1. CONSTRUCT STANDARD CURB
2. CONSTRUCT MOUNTABLE CURB
3. 4" WHITE STRIPE
4. CROSSWALK
5. STORMWATER TREATMENT FACILITY. SEE C61XX SERIES SHEETS FOR DETAILS
6. FLUSH CURB
7. ADA PARKING STALLS AND STRIPING
8. CURB RAMP TYPE X
9. FIRE LANE. PAINT CURB RED AND STENCIL IN WHITE "FIRE LANE NO PARKING". STENCIL LETTER STROKE SIZE SHALL BE 1" WIDE BY 6" HIGH.
10. COORDINATE BUILDING GRID LINE LOCATION WITH ARCHITECTURAL PLANS PRIOR TO CONSTRUCTION.
11. BOLLARD
12. SEE LANDSCAPE PLANS FOR FENCING, HANDGUARD RAILS
13. BIKE PARKING RACKS - SEE LANDSCAPE PLANS
14. WHEEL STOP
15. COMPACT PARKING SPACES
16. CONCRETE TO ASPHALT PAVEMENT TRANSITION
17. CURB CUT TO CURB SPILLWAY
18. DIRECTIONAL ARROWS
19. INSTALL DETECTABLE WARNING STRIP
20. SEE LANDSCAPE PLANS FOR PLAZA LAYOUT
21. RETAINING WALL
22. MULTI-USE FIELD - SEE LANDSCAPE PLANS
23. LIGHT POLE - SEE ELECTRICAL PLANS
24. OFFSITE IMPROVEMENTS SHOWN FOR REFERENCE ONLY. REFER TO OFFSITE PACKAGE.
25. EXISTING PROPERTY LINE
26. ACCESS GATE
27. STAIRS - SEE LANDSCAPE PLANS
28. PROPOSED PROPERTY LINE
29. "NO PARKING" SIGN
30. "NO PARKING FIRE LANE" SIGN
31. "SERVICE VEHICLES ONLY" SIGN
32. "NO PARKING UNLOADING ZONE" SIGN
33. "BUS ONLY" SIGN
34. "STOP" SIGN
35. "CARPOOL/VANPOOL" SIGN
36. "VISITOR PARKING" SIGN
37. "STUDENT DROP OFF AND PICK UP" SIGN
38. (NOT USED)
39. SCUPPER DRAIN
40. ROADWAY CENTERLINE - SEE SHEETS C2201 AND C2202 FOR ROAD PROFILES
41. RETAINING WALL WITH GUARD RAIL
42. PEDESTRIAN ASPHALT SIDEWALK - SEE LANDSCAPE PLANS
43. CONSTRUCT CONCRETE CURB ENDING
44. CURB RAMP TYPE XX
45. CURB RAMP TYPE XXX

SHEET LEGEND

- PROPERTY LINE TO BE DEDICATED
- PROPERTY LINE
- CONVEYANCE SWALE
- SAWCUT LINE
- PROPOSED FENCE (SEE LANDSCAPE PLANS)
- CENTERLINE ROADWAY
- STANDARD CURB
- PAINTED CURB - FIRE LANE
- SITE WALL
- PROPOSED BUILDING
- STORMWATER TREATMENT FACILITY
- ASPHALT PAVEMENT: HEAVY DUTY
- ASPHALT PAVEMENT: MEDIUM DUTY
- ASPHALT PAVEMENT: LIGHT DUTY
- PEDESTRIAN ASPHALT - SEE LANDSCAPE
- HEAVY CONCRETE PAVEMENT
- PEDESTRIAN CONCRETE PAVEMENT - SEE LANDSCAPE FOR LAYOUT, SCORING, AND FINISH
- GRASS PAVERS - SEE LANDSCAPE PLANS
- C COMPACT PARKING STALLS
- LT LEFT
- PC POINT OF CURVATURE
- PCC POINT OF COMPOUND CURVE
- PI POINT OF INTERSECTION
- PT POINT OF TANGENT
- R RADIUS
- RT RIGHT

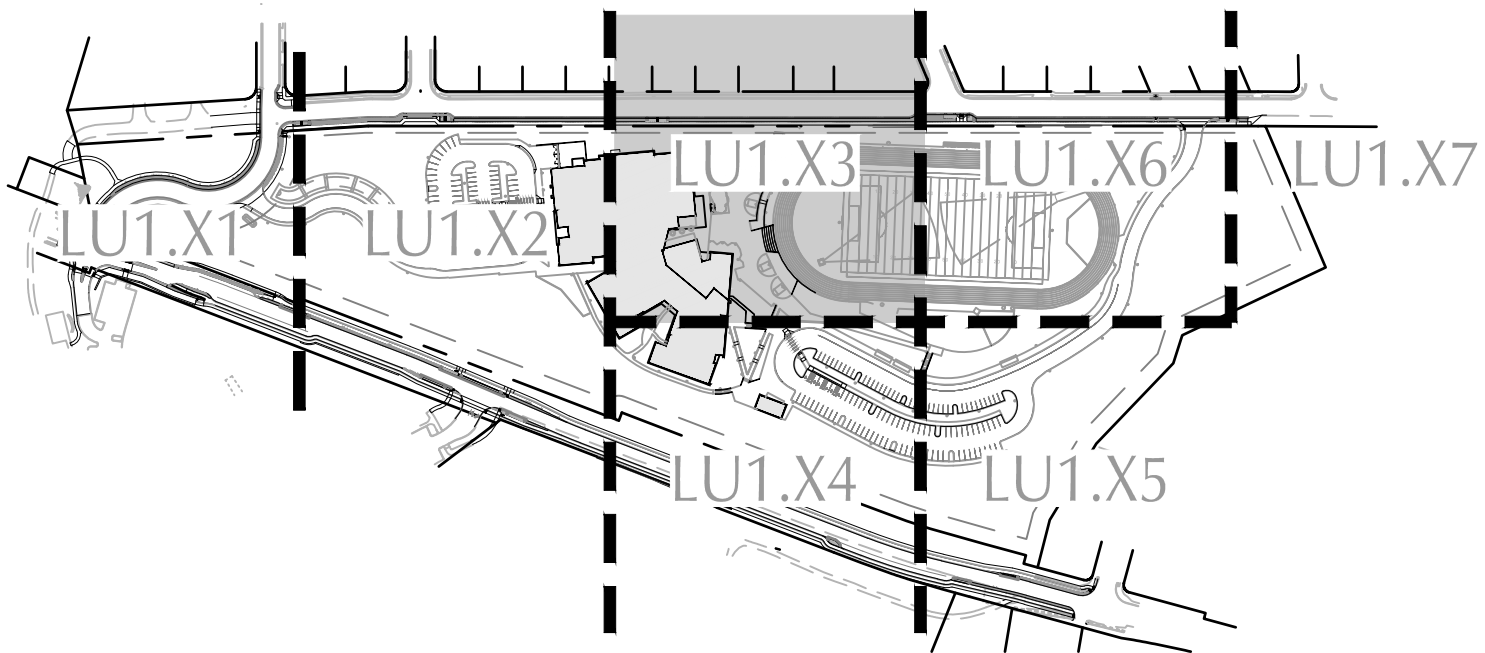

KEY MAP

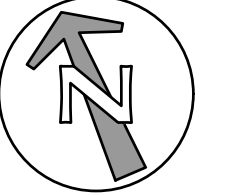

SCALE
1 INCH = 20 FEET
20 0 20 40

CLIENT

West Linn-Wilsonville
School District



22210 SW Stafford Rd, Tualatin, OR 97062

COPYRIGHT

This drawing has been prepared solely for the intended use, and any reproduction or distribution for any purpose other than authorized by BSI Group is forbidden. Written dimensions shall have precedence over scaled dimensions. Contractor shall verify and be responsible for all dimensions and conditions on the job, and BSI Group shall not be liable for any variations from the drawings and conditions shown on the drawing. Shop drawings shall be submitted to BSI Group for general confirmation before proceeding with fabrication.

PLEASE CHOOSE LEGAL ENTITY

is a member of the BSI Group of companies

ISSUES

| No. | DESCRIPTION | DATE |
|-----|-------------|------------|
| 1 | LAND USE | 2021-03-17 |

KEYPLAN

CONSULTANTS

kpf

111 SW Fifth Ave., Suite 2600
Portland, OR 97204
P: 503.542.3860
F: 503.274.4681
www.kpff.com

SEAL



IBI GROUP
907 SW Harvey Milk Street
Portland, OR 97205, USA
tel 503 226 6950 fax 503 273 9192
ibi@group-engineer.com

PROJECT

New Athey Creek Middle School

945 Dollar Street
West Linn, OR 97068

PROJECT NO:

124738

DRAWN BY:

XX

PROJECT MGR:

Designer

SHEET TITLE

CHECKED BY:

Checker

APPROVED BY:

Approver


SITE PLAN



SHEET NUMBER

LU1.13


ISSUE

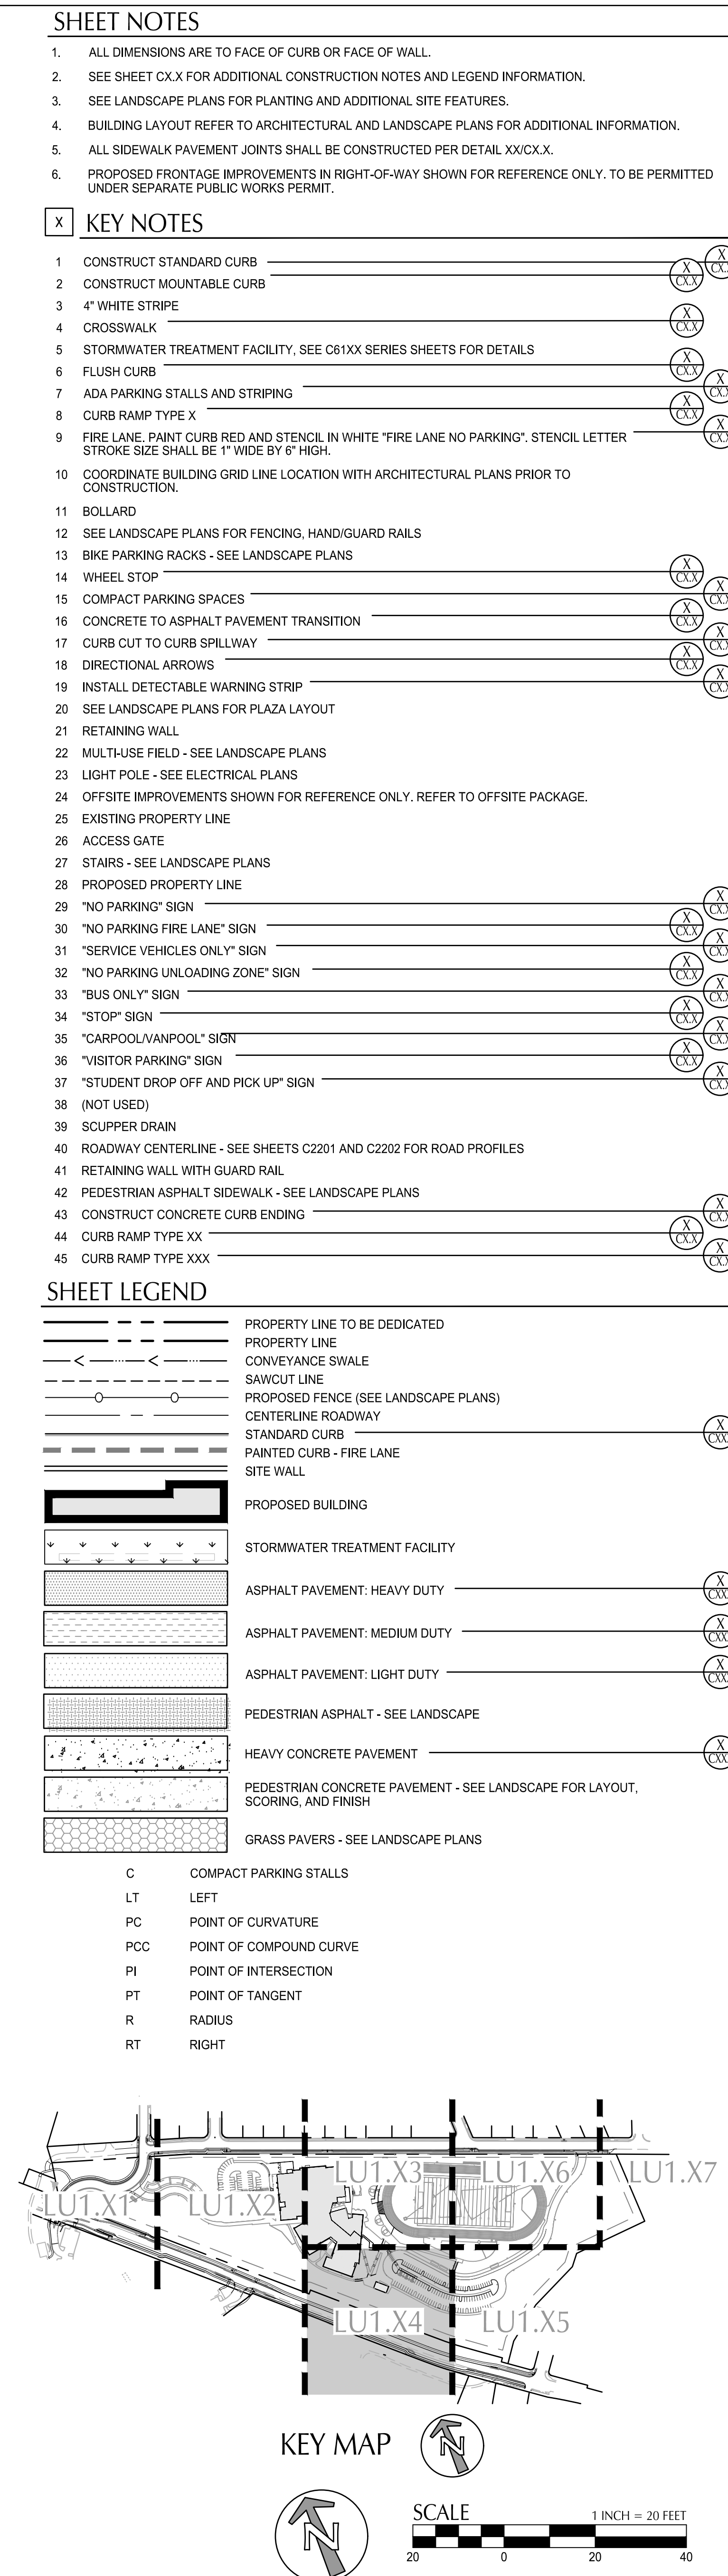A



| <p>CLIENT</p> <p>West Linn-Wilsonville School District</p>  <p>22210 SW Stafford Rd, Tualatin, OR 97062</p> | | | | | | | | | | | |
|--|---------------------------------|---|-----------------------|--|------------------------|-------------------------------|---------------------------------|---------------------------------|---|----------|------------|
| <p>COPYRIGHT</p> <p><small>The drawing has been prepared solely for the intended use. No any reproduction or distribution for any purpose other than authorized by IBI Group is forbidden. All other drawings shall have procedures never stated before. Contractors shall verify and be responsible for all dimensions and conditions on the job, and IBI Group shall be relieved of any liabilities from the dimensions and conditions shown on the drawing. Show drawings shall be submitted to IBI Group for general confirmation before proceeding with fabrication.</small></p> | | | | | | | | | | | |
| <p>PLEASE CHOOSE LEGAL ENTITY is a member of the IBI Group of companies</p> | | | | | | | | | | | |
| <table border="1" style="width: 100%; border-collapse: collapse;"> <tr> <th colspan="3" style="text-align: left; padding: 5px;">ISSUES</th> </tr> <tr> <th style="width: 10%; padding: 5px;">No.</th> <th style="width: 70%; padding: 5px;">DESCRIPTION</th> <th style="width: 20%; padding: 5px;">DATE</th> </tr> <tr> <td style="text-align: center; padding: 5px;">1</td> <td style="padding: 5px;">LAND USE</td> <td style="text-align: center; padding: 5px;">2021-03-17</td> </tr> </table> | | | ISSUES | | | No. | DESCRIPTION | DATE | 1 | LAND USE | 2021-03-17 |
| ISSUES | | | | | | | | | | | |
| No. | DESCRIPTION | DATE | | | | | | | | | |
| 1 | LAND USE | 2021-03-17 | | | | | | | | | |
| <p>KEYPLAN</p> | | | | | | | | | | | |
| <p>CONSULTANTS</p> <div style="text-align: center; margin-top: 50px;">  </div> <div style="text-align: center; margin-top: 20px;"> <p>111 SW Fifth Ave., Suite 2600 Portland, OR 97204 O: 503 542 3860 F: 503 274 4661 www.kpff.com</p> </div> | | | | | | | | | | | |
| <p>SEAL</p> | | | | | | | | | | | |
| <div style="display: flex; align-items: center; justify-content: center;"> <div style="border: 2px solid black; padding: 10px; margin-right: 10px; text-align: center;"> IBI </div> <div> <p>IBI GROUP 907 SW Harvey Milk Street Portland, OR 97205, USA tel: 503 226 6950 fax: 503 273 9192 ibigroup-edpnm.com</p> </div> </div> | | | | | | | | | | | |
| <p>PROJECT</p> <p>New Athey Creek Middle School</p> <p style="text-align: center; margin-top: 20px;">945 Dollar Street West Linn, OR 97068</p> | | | | | | | | | | | |
| <table border="1" style="width: 100%; border-collapse: collapse;"> <tr> <td colspan="2" style="padding: 5px;">PROJECT NO: 124738</td> </tr> <tr> <td style="width: 50%; padding: 5px;">DRAWN BY: XX</td> <td style="width: 50%; padding: 5px;">CHECKED BY: Checker</td> </tr> <tr> <td style="padding: 5px;">PROJECT MGR: Designer</td> <td style="padding: 5px;">APPROVED BY: Approver</td> </tr> </table> | | | PROJECT NO: 124738 | | DRAWN BY: XX | CHECKED BY: Checker | PROJECT MGR: Designer | APPROVED BY: Approver | | | |
| PROJECT NO: 124738 | | | | | | | | | | | |
| DRAWN BY: XX | CHECKED BY: Checker | | | | | | | | | | |
| PROJECT MGR: Designer | APPROVED BY: Approver | | | | | | | | | | |
| <p>SHEET TITLE</p> <p style="text-align: center; font-size: 1.2em;">SITE PLAN</p> | | | | | | | | | | | |
| <p>SHEET NUMBER</p> <p style="font-size: 1.5em; text-align: center;">LU1.14</p> | | <p>ISSUE</p> <p style="font-size: 1.5em; text-align: center;">A</p> | | | | | | | | | |

File: N:\2020\09\09\093-Dollar-School\SCAD\PL01\U0000067-LU11-SITE.dwg TAB:LU1.15
Plotter: 3/16/21 at 4:25pm By: mmaner
2020-07-17 12:31:12 PM

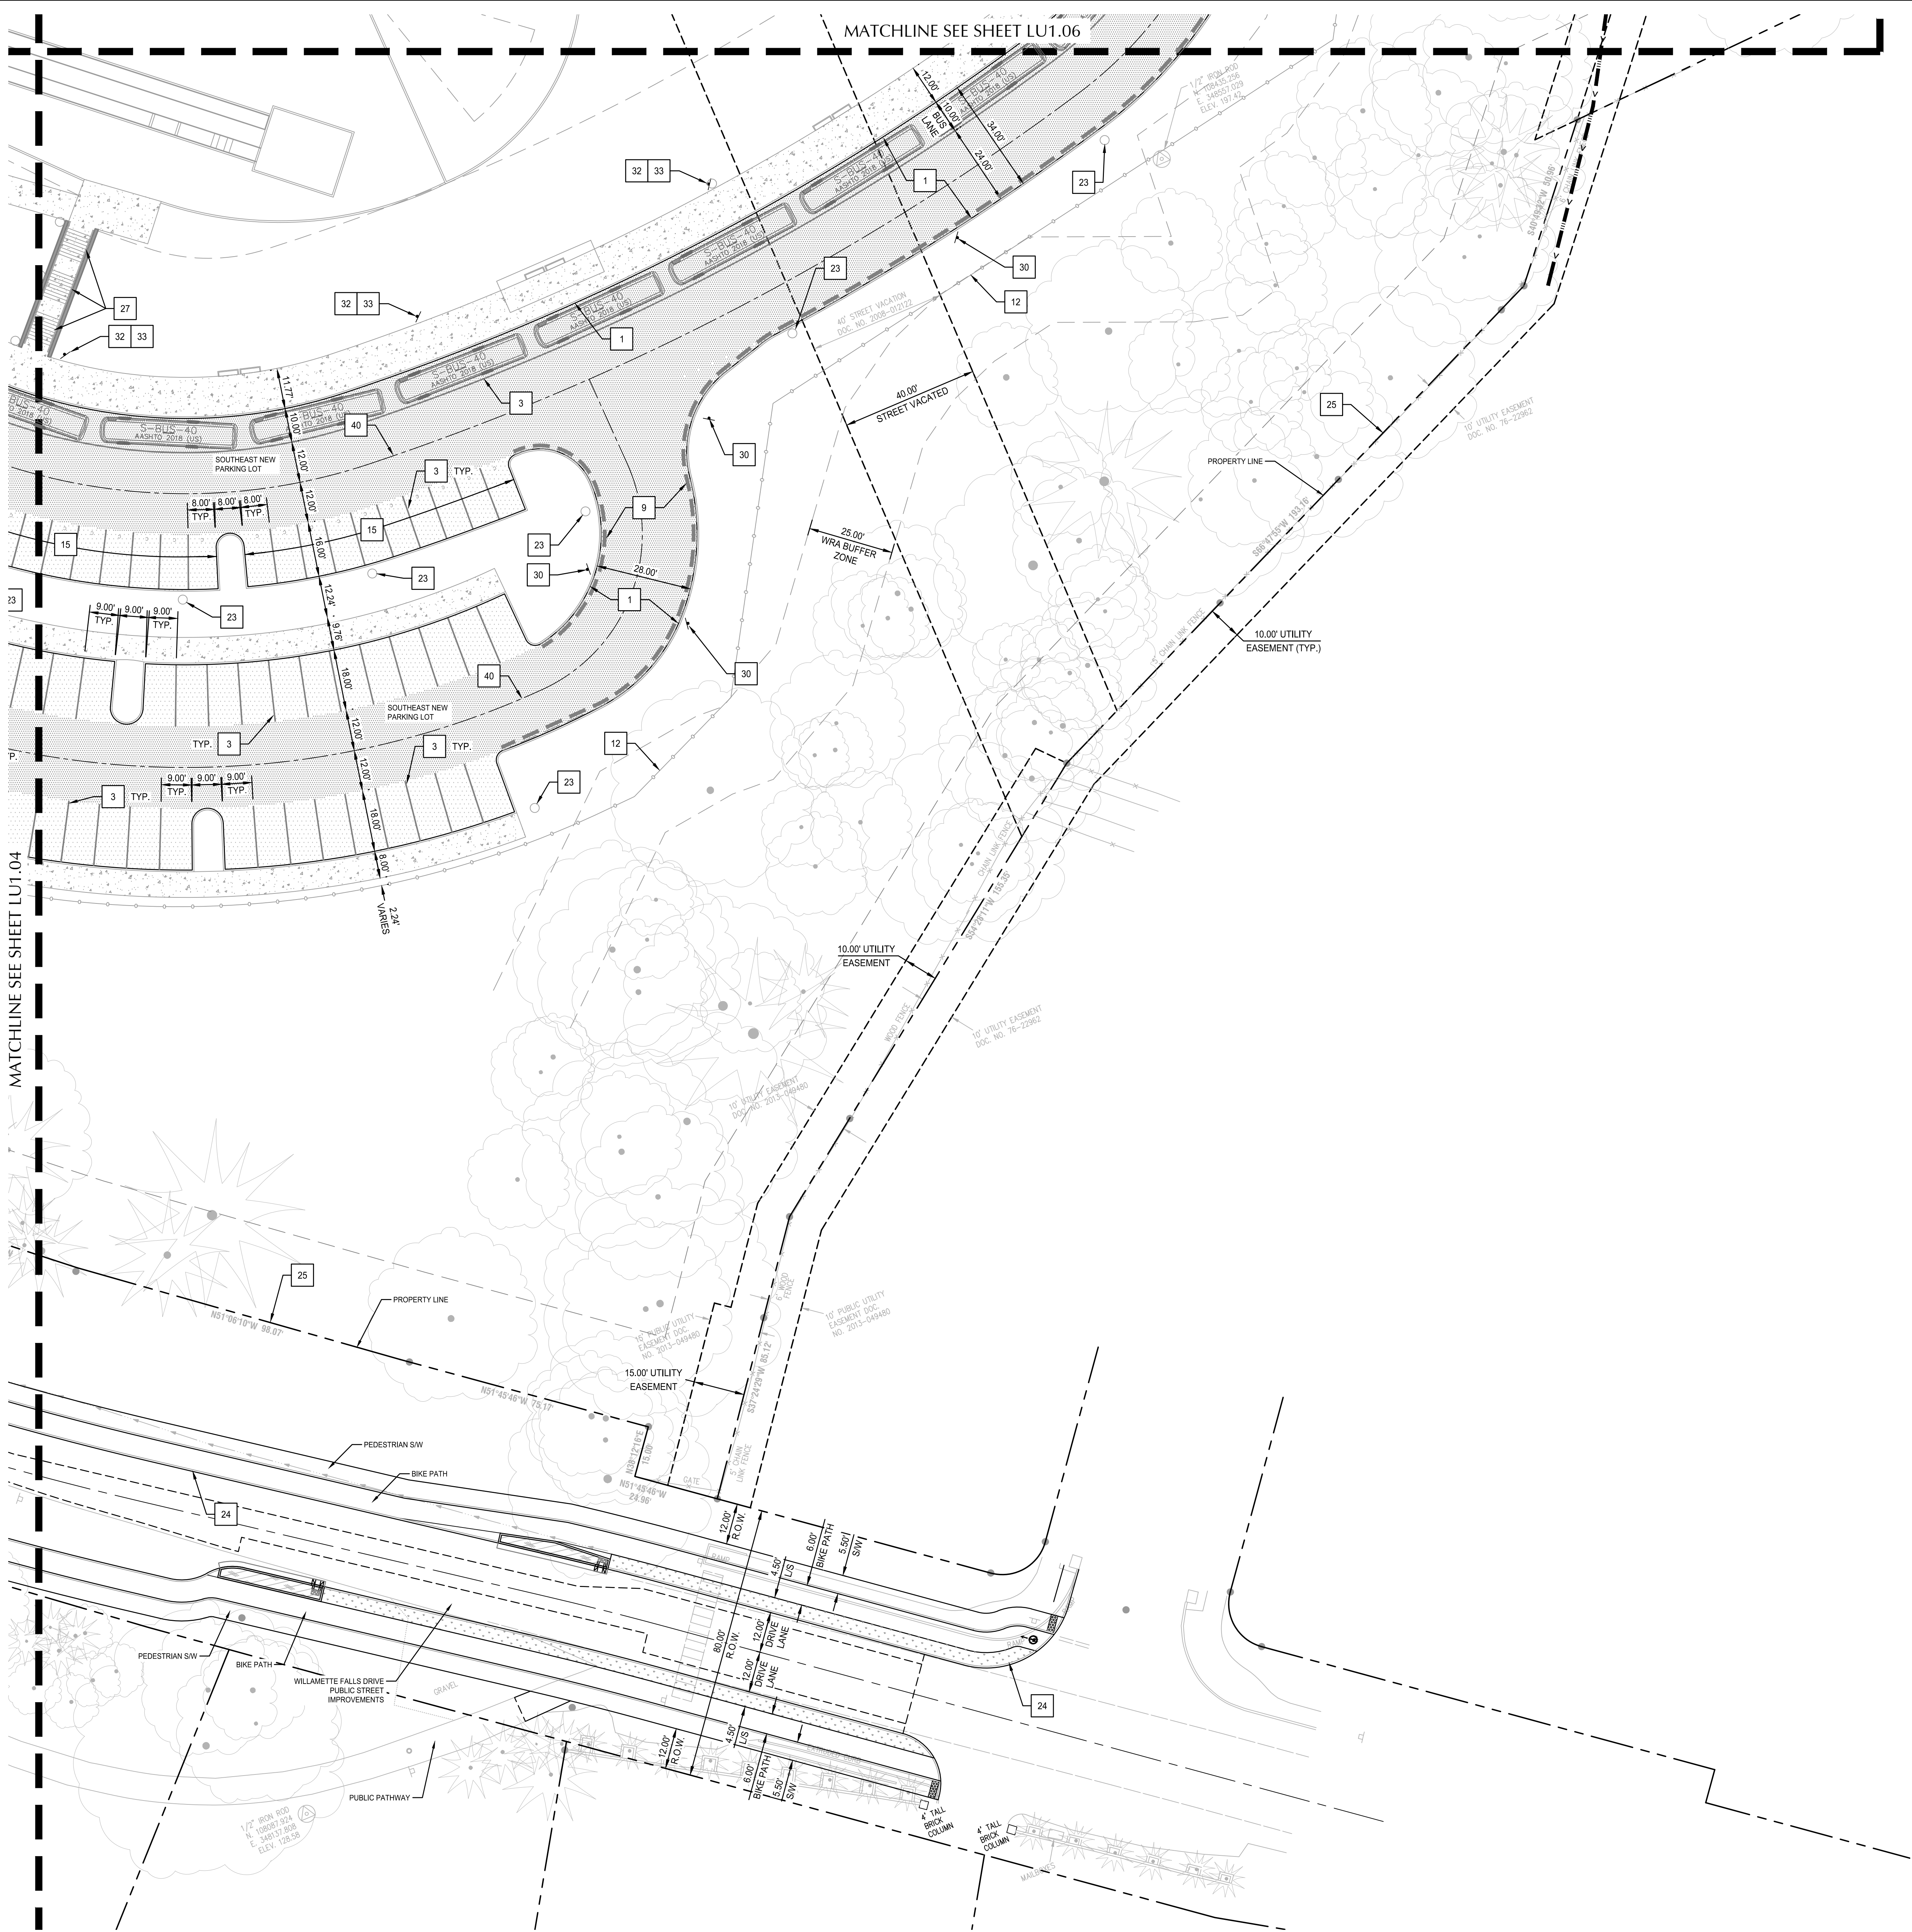

SHEET NOTES


1. ALL DIMENSIONS ARE TO FACE OF CURB OR FACE OF WALL.
2. SEE SHEET CX.X FOR ADDITIONAL CONSTRUCTION NOTES AND LEGEND INFORMATION.
3. SEE LANDSCAPE PLANS FOR PLANTING AND ADDITIONAL SITE FEATURES.
4. BUILDING LAYOUT REFER TO ARCHITECTURAL AND LANDSCAPE PLANS FOR ADDITIONAL INFORMATION.
5. ALL SIDEWALK PAVEMENT JOINTS SHALL BE CONSTRUCTED PER DETAIL XXCX.X.
6. PROPOSED FRONTAGE IMPROVEMENTS IN RIGHT-OF-WAY SHOWN FOR REFERENCE ONLY. TO BE PERMITTED UNDER SEPARATE PUBLIC WORKS PERMIT.

KEY NOTES


- | | | |
|----|--|----------|
| 1 | CONSTRUCT STANDARD CURB | (X) (CX) |
| 2 | CONSTRUCT MOUNTABLE CURB | (X) (CX) |
| 3 | 4" WHITE STRIPE | (X) (CX) |
| 4 | CROSSWALK | (X) (CX) |
| 5 | STORMWATER TREATMENT FACILITY. SEE C61XX SERIES SHEETS FOR DETAILS | (X) (CX) |
| 6 | FLUSH CURB | (X) (CX) |
| 7 | ADA PARKING STALLS AND STRIPING | (X) (CX) |
| 8 | CURB RAMP TYPE X | (X) (CX) |
| 9 | FIRE LANE. PAINT CURB RED AND STENCIL IN WHITE "FIRE LANE NO PARKING". STENCIL LETTER STROKE SIZE SHALL BE 1" WIDE BY 6" HIGH. | (X) (CX) |
| 10 | COORDINATE BUILDING GRID LINE LOCATION WITH ARCHITECTURAL PLANS PRIOR TO CONSTRUCTION. | (X) (CX) |
| 11 | BOLLARD | (X) (CX) |
| 12 | SEE LANDSCAPE PLANS FOR FENCING, HAND/GUARD RAILS | (X) (CX) |
| 13 | BIKE PARKING RACKS - SEE LANDSCAPE PLANS | (X) (CX) |
| 14 | WHEEL STOP | (X) (CX) |
| 15 | COMPACT PARKING SPACES | (X) (CX) |
| 16 | CONCRETE TO ASPHALT PAVEMENT TRANSITION | (X) (CX) |
| 17 | CURB CUT TO CURB SPILLWAY | (X) (CX) |
| 18 | DIRECTIONAL ARROWS | (X) (CX) |
| 19 | INSTALL DETECTABLE WARNING STRIP | (X) (CX) |
| 20 | SEE LANDSCAPE PLANS FOR PLAZA LAYOUT | (X) (CX) |
| 21 | RETAINING WALL | (X) (CX) |
| 22 | MULTI-USE FIELD - SEE LANDSCAPE PLANS | (X) (CX) |
| 23 | LIGHT POLE - SEE ELECTRICAL PLANS | (X) (CX) |
| 24 | OFFSITE IMPROVEMENTS SHOWN FOR REFERENCE ONLY. REFER TO OFFSITE PACKAGE. | (X) (CX) |
| 25 | EXISTING PROPERTY LINE | (X) (CX) |
| 26 | ACCESS GATE | (X) (CX) |
| 27 | STAIRS - SEE LANDSCAPE PLANS | (X) (CX) |
| 28 | PROPOSED PROPERTY LINE | (X) (CX) |
| 29 | "NO PARKING" SIGN | (X) (CX) |
| 30 | "NO PARKING FIRE LANE" SIGN | (X) (CX) |
| 31 | "SERVICE VEHICLES ONLY" SIGN | (X) (CX) |
| 32 | "NO PARKING UNLOADING ZONE" SIGN | (X) (CX) |
| 33 | "BUS ONLY" SIGN | (X) (CX) |
| 34 | "STOP" SIGN | (X) (CX) |
| 35 | "CARPOOL/VANPOOL" SIGN | (X) (CX) |
| 36 | "VISITOR PARKING" SIGN | (X) (CX) |
| 37 | "STUDENT DROP OFF AND PICK UP" SIGN | (X) (CX) |
| 38 | (NOT USED) | (X) (CX) |
| 39 | SCUPPER DRAIN | (X) (CX) |
| 40 | ROADWAY CENTERLINE - SEE SHEETS C2201 AND C2202 FOR ROAD PROFILES | (X) (CX) |
| 41 | RETAINING WALL WITH GUARD RAIL | (X) (CX) |
| 42 | PEDESTRIAN ASPHALT SIDEWALK - SEE LANDSCAPE PLANS | (X) (CX) |
| 43 | CONSTRUCT CONCRETE CURB ENDING | (X) (CX) |
| 44 | CURB RAMP TYPE XX | (X) (CX) |
| 45 | CURB RAMP TYPE XXX | (X) (CX) |

SHEET LEGEND

- | | | |
|--|--|----------|
| | PROPERTY LINE TO BE DEDICATED | |
| | CONVEYANCE SWALE | |
| | SAWCUT LINE | |
| | PROPOSED FENCE (SEE LANDSCAPE PLANS) | |
| | CENTERLINE ROADWAY | |
| | STANDARD CURB | (X) (CX) |
| | PAINTED CURB - FIRE LANE | (X) (CX) |
| | SITE WALL | (X) (CX) |
| | PROPOSED BUILDING | |
| | STORMWATER TREATMENT FACILITY | |
| | ASPHALT PAVEMENT: HEAVY DUTY | (X) (CX) |
| | ASPHALT PAVEMENT: MEDIUM DUTY | (X) (CX) |
| | ASPHALT PAVEMENT: LIGHT DUTY | (X) (CX) |
| | PEDESTRIAN ASPHALT - SEE LANDSCAPE | |
| | HEAVY CONCRETE PAVEMENT | (X) (CX) |
| | PEDESTRIAN CONCRETE PAVEMENT - SEE LANDSCAPE FOR LAYOUT, SCORING, AND FINISH | |
| | GRASS PAVERS - SEE LANDSCAPE PLANS | |
-
- | | |
|-----|-------------------------|
| C | COMPACT PARKING STALLS |
| LT | LEFT |
| PC | POINT OF CURVATURE |
| PCC | POINT OF COMPOUND CURVE |
| PI | POINT OF INTERSECTION |
| PT | POINT OF TANGENT |
| R | RADIUS |
| RT | RIGHT |

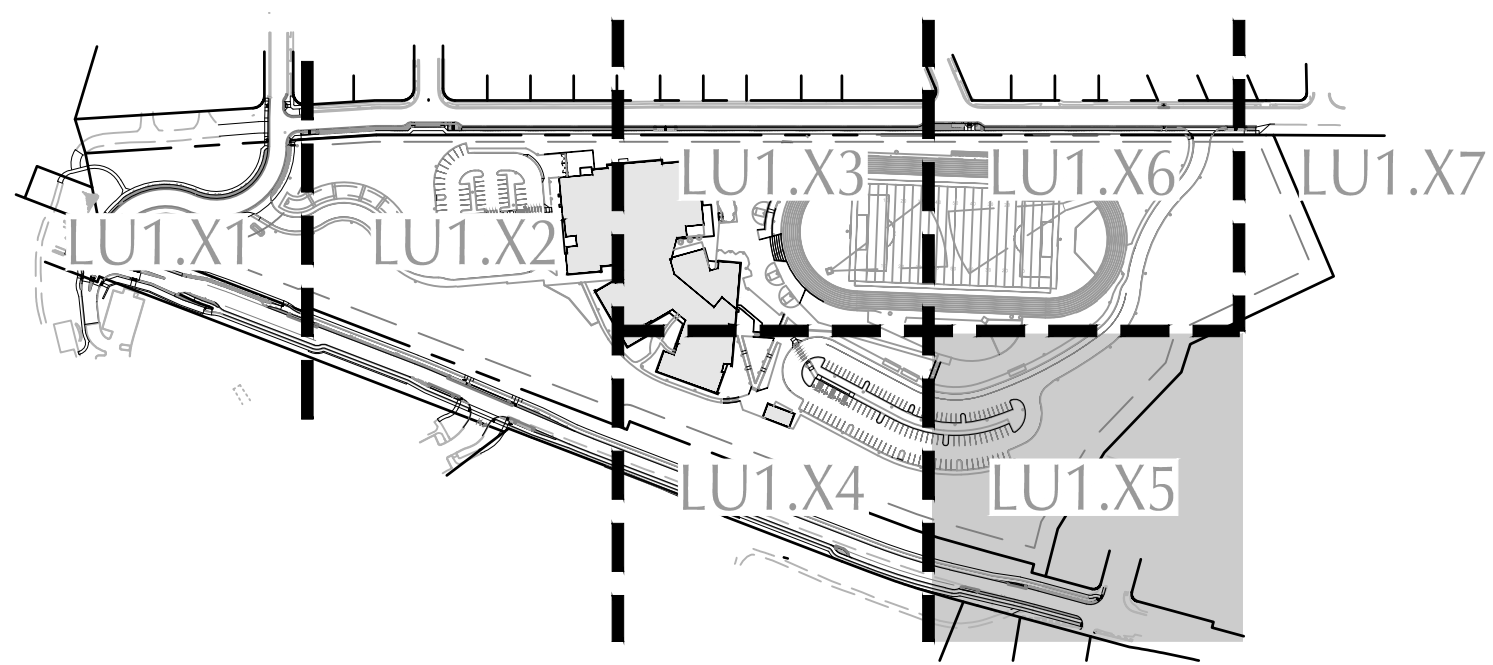

KEY MAP

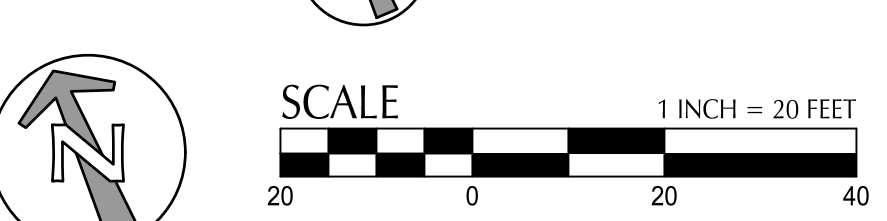

CLIENT

West Linn-Wilsonville School District

22210 SW Stafford Rd, Tualatin, OR 97062

COPYRIGHT

This drawing has been prepared solely for the intended use, and any reproduction or distribution for any purpose other than authorized by BGI Group is forbidden. Written dimensions shall have precedence over scaled dimensions. Contractor shall verify and be responsible for all dimensions and conditions on the job, and BGI Group shall not be liable for any variations from the dimensions and conditions shown on the drawing. Shop drawings shall be submitted to BGI Group for general performance before proceeding with fabrication.

PLEASE CHOOSE LEGAL ENTITY

is a member of the BGI Group of companies

| ISSUES | DESCRIPTION | DATE |
|--------|-------------|------------|
| No. 1 | LAND USE | 2021-03-17 |

KEYPLAN

CONSULTANTS

kpf

111 SW Fifth Ave., Suite 2600
Portland, OR 97204
P: 503.542.3660
F: 503.274.4681
www.kpf.com

SEAL

PROJECT

New Athey Creek Middle School

945 Dollar Street
West Linn, OR 97068


| | |
|--------------------------|--------------------------|
| PROJECT NO: 124738 | CHECKED BY: Checker |
| DRAWN BY: XX | APPROVED BY: Approver |
| PROJECT MGR: Designer | |
| SHEET TITLE | |



SHEET NUMBER

LU1.15


ISSUE

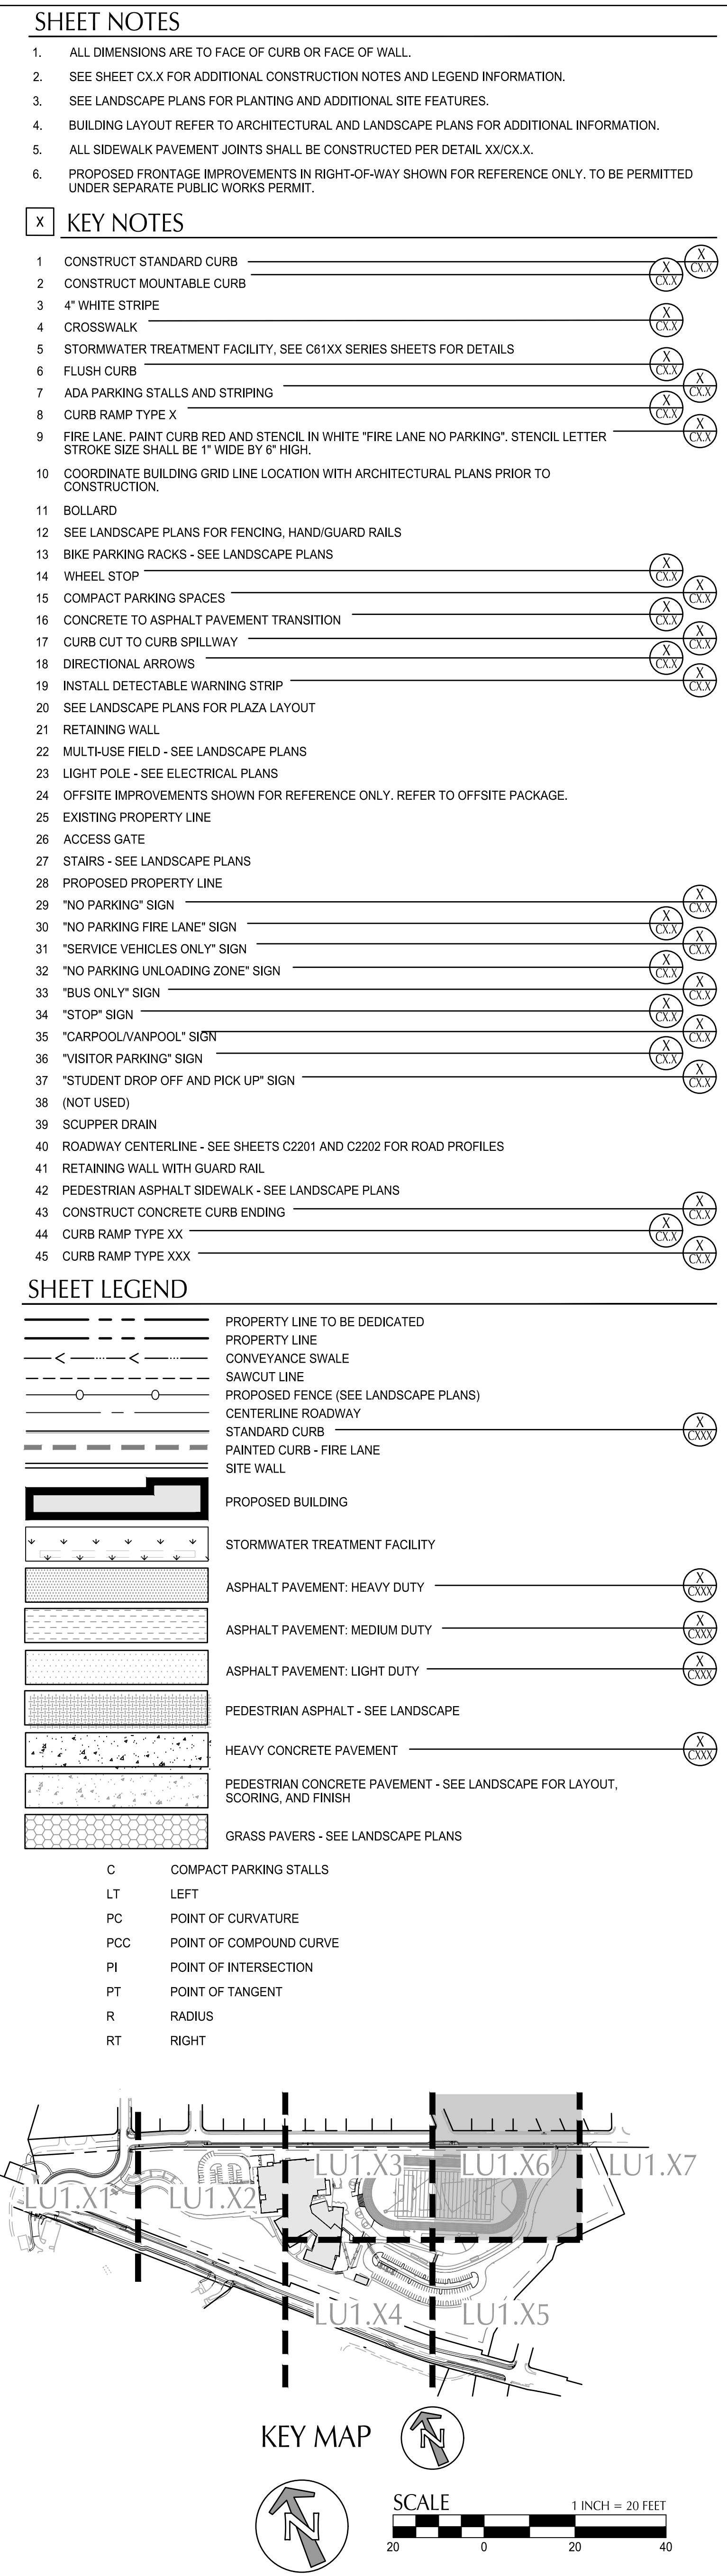A



| | | |
|--|--------------------------|------------|
| CLIENT | | |
| West Linn-Wilsonville School District | | |
|  | | |
| 22210 SW Stafford Rd, Tualatin, OR 97062 | | |
| COPYRIGHT | | |
| <small>The drawing has been prepared solely for the intended use. No any reproduction or distribution for any purpose other than authorized by IBI Group is forbidden. Further provisions shall have precedence over stated provisions. Contractors shall verify and be responsible for all dimensions and conditions on the job, and IBI Group shall be relieved of any liabilities from the dimensions and conditions shown on the drawing. Such drawings shall be submitted to IBI Group for general contractor before proceeding with fabrication.</small> | | |
| PLEASE CHOOSE LEGAL ENTITY <small>is a member of the IBI Group of companies</small> | | |
| ISSUES | | |
| No. | DESCRIPTION | DATE |
| 1 | LAND USE | 2021-03-17 |
| | | |
| KEYPLAN | | |
| | | |
| CONSULTANTS | | |
|  | | |
| 111 SW Fifth Ave., Suite 2600 Portland, OR 97204 O: 503.542.3860 F: 503.274.4641 www.kpff.com | | |
| | | |
| SEAL | | |
| | | |
| | | |
| | | |
| IBI GROUP 907 SW Harvey Milk Street Portland, OR 97205, USA tel 503 226 8950 fax 503 273 9192 ibi@group-adpne.com | | |
| PROJECT | | |
| New Athey Creek Middle School | | |
| 945 Dollar Street West Linn, OR 97068 | | |
| PROJECT NO: 124738 | | |
| DRAWN BY: XX | CHECKED BY: Checker | |
| PROJECT MGR: Designer | APPROVED BY: Approver | |
| SHEET TITLE | | |
| SITE PLAN | | |
| SHEET NUMBER | | ISSUE |
| LU1.16 | | A |

File: N:\c\2020\09\09\03 Dollar Street\A1\SCAD\PILOT\U0000067-LU111-SITE.dwg TAB:LU1.17
Plotted: 3/10/21 at 4:25pm By: mmanter
2020-07-17 12:31:12 PM

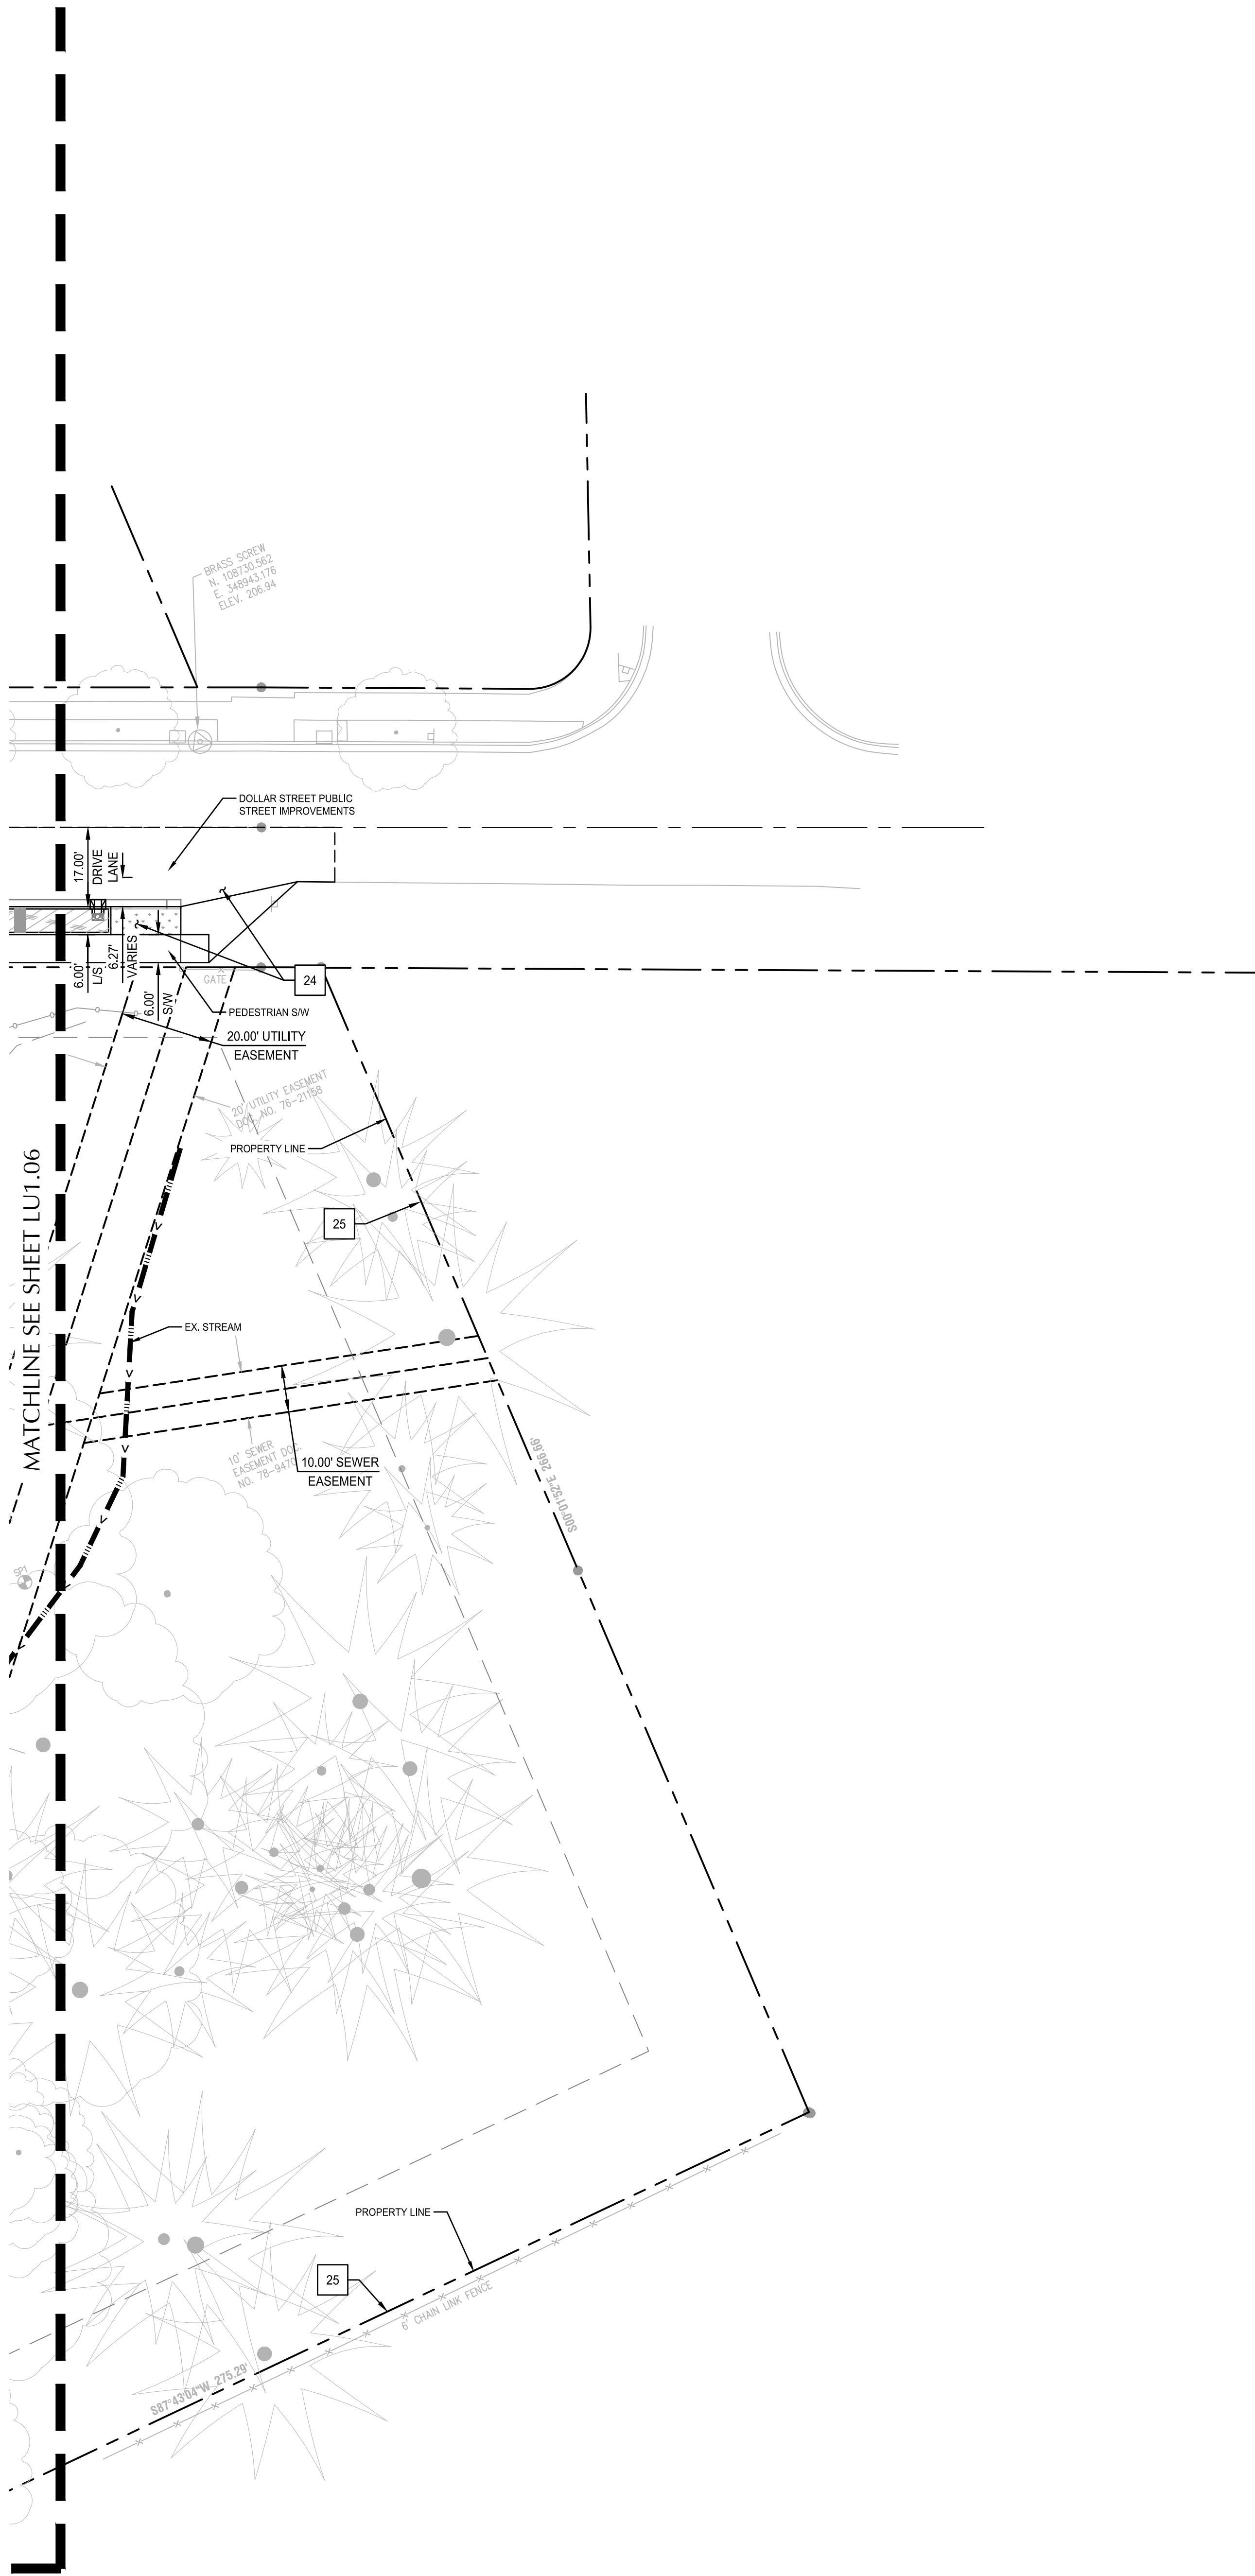

SHEET NOTES


1. ALL DIMENSIONS ARE TO FACE OF CURB OR FACE OF WALL.
2. SEE SHEET CXX FOR ADDITIONAL CONSTRUCTION NOTES AND LEGEND INFORMATION.
3. SEE LANDSCAPE PLANS FOR PLANTING AND ADDITIONAL SITE FEATURES.
4. BUILDING LAYOUT REFER TO ARCHITECTURAL AND LANDSCAPE PLANS FOR ADDITIONAL INFORMATION.
5. ALL SIDEWALK PAVEMENT JOINTS SHALL BE CONSTRUCTED PER DETAIL XX/CXX.
6. PROPOSED FRONTAGE IMPROVEMENTS IN RIGHT-OF-WAY SHOWN FOR REFERENCE ONLY. TO BE PERMITTED UNDER SEPARATE PUBLIC WORKS PERMIT.

KEY NOTES

- | | | |
|----|--|-----------|
| 1 | CONSTRUCT STANDARD CURB | (X) (CXX) |
| 2 | CONSTRUCT MOUNTABLE CURB | (X) (CXX) |
| 3 | 4" WHITE STRIPE | (X) (CXX) |
| 4 | CROSSWALK | (X) (CXX) |
| 5 | STORMWATER TREATMENT FACILITY. SEE C61XX SERIES SHEETS FOR DETAILS | (X) (CXX) |
| 6 | FLUSH CURB | (X) (CXX) |
| 7 | ADA PARKING STALLS AND STRIPING | (X) (CXX) |
| 8 | CURB RAMP TYPE X | (X) (CXX) |
| 9 | FIRE LANE. PAINT CURB RED AND STENCIL IN WHITE "FIRE LANE NO PARKING". STENCIL LETTER STROKE SIZE SHALL BE 1" WIDE BY 6" HIGH. | (X) (CXX) |
| 10 | COORDINATE BUILDING GRID LINE LOCATION WITH ARCHITECTURAL PLANS PRIOR TO CONSTRUCTION. | |
| 11 | BOLLARD | |
| 12 | SEE LANDSCAPE PLANS FOR FENCING, HAND/GUARD RAILS | |
| 13 | BIKE PARKING RACKS - SEE LANDSCAPE PLANS | |
| 14 | WHEEL STOP | (X) (CXX) |
| 15 | COMPACT PARKING SPACES | (X) (CXX) |
| 16 | CONCRETE TO ASPHALT PAVEMENT TRANSITION | (X) (CXX) |
| 17 | CURB CUT TO CURB SPILLWAY | (X) (CXX) |
| 18 | DIRECTIONAL ARROWS | (X) (CXX) |
| 19 | INSTALL DETECTABLE WARNING STRIP | (X) (CXX) |
| 20 | SEE LANDSCAPE PLANS FOR PLAZA LAYOUT | |
| 21 | RETAINING WALL | |
| 22 | MULTI-USE FIELD - SEE LANDSCAPE PLANS | |
| 23 | LIGHT POLE - SEE ELECTRICAL PLANS | |
| 24 | OFFSITE IMPROVEMENTS SHOWN FOR REFERENCE ONLY. REFER TO OFFSITE PACKAGE. | |
| 25 | EXISTING PROPERTY LINE | |
| 26 | ACCESS GATE | |
| 27 | STAIRS - SEE LANDSCAPE PLANS | |
| 28 | PROPOSED PROPERTY LINE | |
| 29 | "NO PARKING" SIGN | (X) (CXX) |
| 30 | "NO PARKING FIRE LANE" SIGN | (X) (CXX) |
| 31 | "SERVICE VEHICLES ONLY" SIGN | (X) (CXX) |
| 32 | "NO PARKING UNLOADING ZONE" SIGN | (X) (CXX) |
| 33 | "BUS ONLY" SIGN | (X) (CXX) |
| 34 | "STOP" SIGN | (X) (CXX) |
| 35 | "CARPOOL/VANPOOL" SIGN | (X) (CXX) |
| 36 | "VISITOR PARKING" SIGN | (X) (CXX) |
| 37 | "STUDENT DROP OFF AND PICK UP" SIGN | (X) (CXX) |
| 38 | (NOT USED) | |
| 39 | SCUPPER DRAIN | |
| 40 | ROADWAY CENTERLINE - SEE SHEETS C2201 AND C2202 FOR ROAD PROFILES | |
| 41 | RETAINING WALL WITH GUARD RAIL | |
| 42 | PEDESTRIAN ASPHALT SIDEWALK - SEE LANDSCAPE PLANS | |
| 43 | CONSTRUCT CONCRETE CURB ENDING | (X) (CXX) |
| 44 | CURB RAMP TYPE XX | (X) (CXX) |
| 45 | CURB RAMP TYPE XXX | (X) (CXX) |

SHEET LEGEND

- | | | |
|--------------------------|--|-----------|
| --- | PROPERTY LINE TO BE DEDICATED | |
| - - - | PROPERTY LINE | |
| - < - - - < - | CONVEYANCE SWALE | |
| - < - - - < - | SAWCUT LINE | |
| - < - - - < - | PROPOSED FENCE (SEE LANDSCAPE PLANS) | |
| - < - - - < - | CENTERLINE ROADWAY | |
| - < - - - < - | STANDARD CURB | (X) (CXX) |
| - < - - - < - | PAINTED CURB - FIRE LANE | (X) (CXX) |
| - < - - - < - | SITE WALL | |
| [Solid Box] | PROPOSED BUILDING | |
| [Stippled Box] | STORMWATER TREATMENT FACILITY | |
| [Cross-hatched Box] | ASPHALT PAVEMENT: HEAVY DUTY | (X) (CXX) |
| [Diagonal-hatched Box] | ASPHALT PAVEMENT: MEDIUM DUTY | (X) (CXX) |
| [Horizontal-hatched Box] | ASPHALT PAVEMENT: LIGHT DUTY | (X) (CXX) |
| [Vertical-hatched Box] | PEDESTRIAN ASPHALT - SEE LANDSCAPE | (X) (CXX) |
| [Dotted Box] | HEAVY CONCRETE PAVEMENT | (X) (CXX) |
| [Patterned Box] | PEDESTRIAN CONCRETE PAVEMENT - SEE LANDSCAPE FOR LAYOUT, SCORING, AND FINISH | (X) (CXX) |
| [Patterned Box] | GRASS PAVERS - SEE LANDSCAPE PLANS | |
| C | COMPACT PARKING STALLS | |
| LT | LEFT | |
| PC | POINT OF CURVATURE | |
| PCC | POINT OF COMPOUND CURVE | |
| PI | POINT OF INTERSECTION | |
| PT | POINT OF TANGENT | |
| R | RADIUS | |
| RT | RIGHT | |

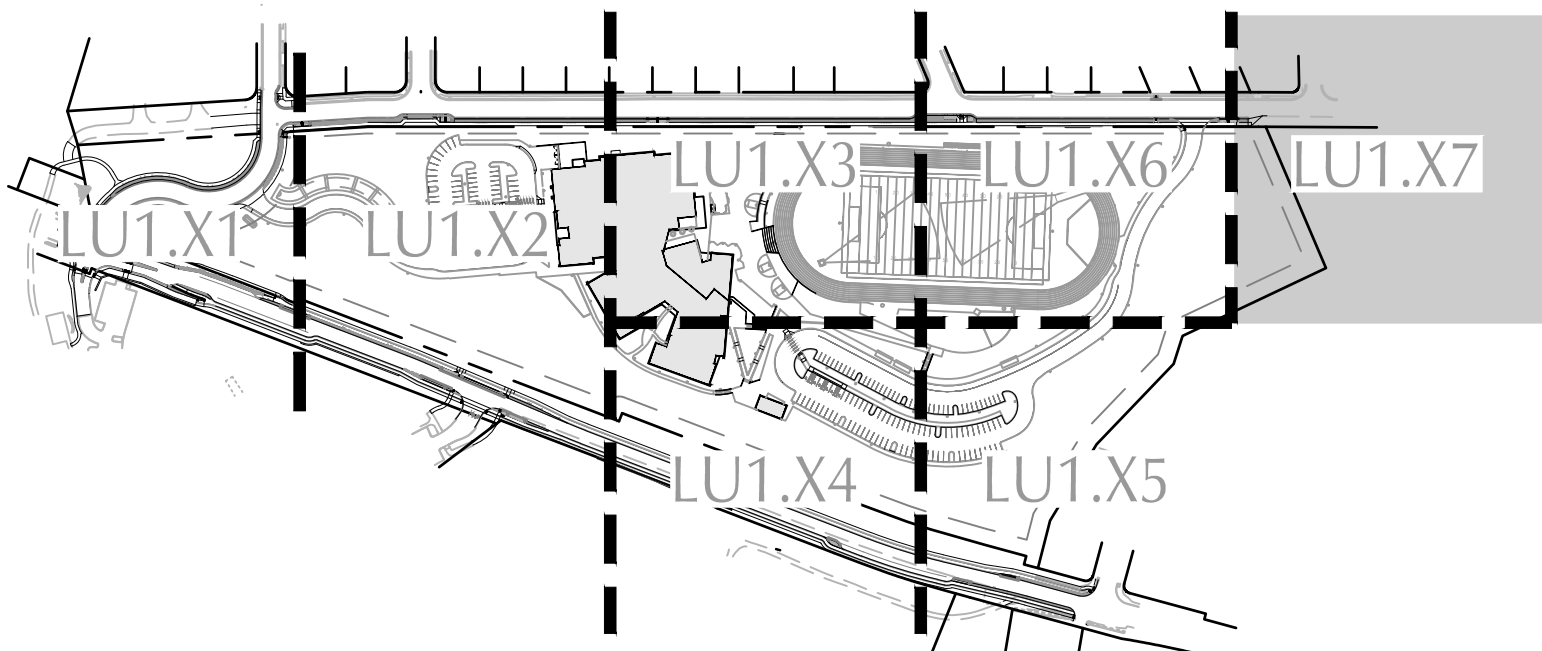

KEY MAP



SCALE



20 0 20 40

CLIENT

West Linn-Wilsonville
School District



22210 SW Stafford Rd, Tualatin, OR 97062

COPYRIGHT

This drawing has been prepared solely for the intended use, thus any reproduction or distribution for any purpose other than authorized by BSI Group is forbidden. Written dimensions shall have precedence over scaled dimensions. Contractors shall verify and be responsible for all dimensions and conditions on the job, and BSI Group shall not be liable for any variations from the dimensions and conditions shown on the drawing. Shop drawings shall be submitted to BSI Group for general confirmation before proceeding with fabrication.

PLEASE CHOOSE LEGAL ENTITY
is a member of the BSI Group of companies

ISSUES

| No. | DESCRIPTION | DATE |
|-----|-------------|------------|
| 1 | LAND USE | 2021-03-17 |

KEYPLAN

CONSULTANTS



111 SW Fifth Ave., Suite 2600
Portland, OR 97204
P: 503.542.3860
F: 503.274.4681
www.kpf.com

SEAL



IBI GROUP
907 SW Harvey Milk Street
Portland, OR 97205, USA
tel 503 226 6950 fax 503 273 9192
ibi@group-ndg.com

PROJECT

New Athey Creek Middle School

945 Dollar Street
West Linn, OR 97068

PROJECT NO:
124738

DRAWN BY:
XX

CHECKED BY:
Checker

PROJECT MGR:
Designer

APPROVED BY:
Approver

SHEET TITLE

SITE PLAN

SHEET NUMBER

LU1.17

ISSUE

A





| <u>CALLOUT</u> | <u>DESCRIPTION</u> |
|---|--|
| <u>X.X%</u> | GRADING SLOPE AND DIRECTION (DOWNHILL) |

The diagram illustrates a drainage ditch cross-section with the following features and labels:

- DRAINAGE FLOW DIRECTION:** Indicated by a curved arrow pointing to the right at the top of the ditch.
- GRADE BREAK:** A dashed line representing a change in the ditch's slope.
- EX. CONTOUR MINOR:** A dashed line labeled "49" representing a minor contour.
- EX. CONTOUR MAJOR:** A dashed line labeled "50" representing a major contour.
- CONTOUR MINOR (FG):** A solid line labeled "49" representing a minor contour on the finished ground.
- CONTOUR MAJOR (FG):** A solid line labeled "50" representing a major contour on the finished ground.
- CONVEYANCE SWALE:** A line with a triangle symbol representing a swale for conveyance.

UTILITY TYPE (SD=STORM DRAINAGE PUB-SD=PUBLIC STORM DRAINAGE)
 STRUCTURE TYPE CALLOUT
 ID NUMBER (WHERE APPLICABLE)
 XX XX-XX
 IE IN = XX.X
 IE OUT = XX.X
 STRUCTURE INFO (WHERE APPLICABLE)

| <u>CALLOUT</u> | <u>DESCRIPTION</u> |
|----------------|-------------------------|
| AD | AREA DRAIN |
| BWV | BACKWATER VALVE |
| CB | CATCH BASIN |
| CI | CURB INLET |
| CO | CLEANOUT TO GRADE |
| DI | DITCH INLET |
| FTMH | FLAT TOP MANHOLE |
| GI | GUTTER INLET |
| MH | MANHOLE |
| OF | OUTFALL |
| OV | OVERFLOW INLET |
| SFCB | STORMFITTER CATCH BASIN |
| WQMh | WATER QUALITY MANHOLE |

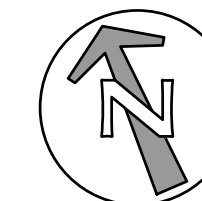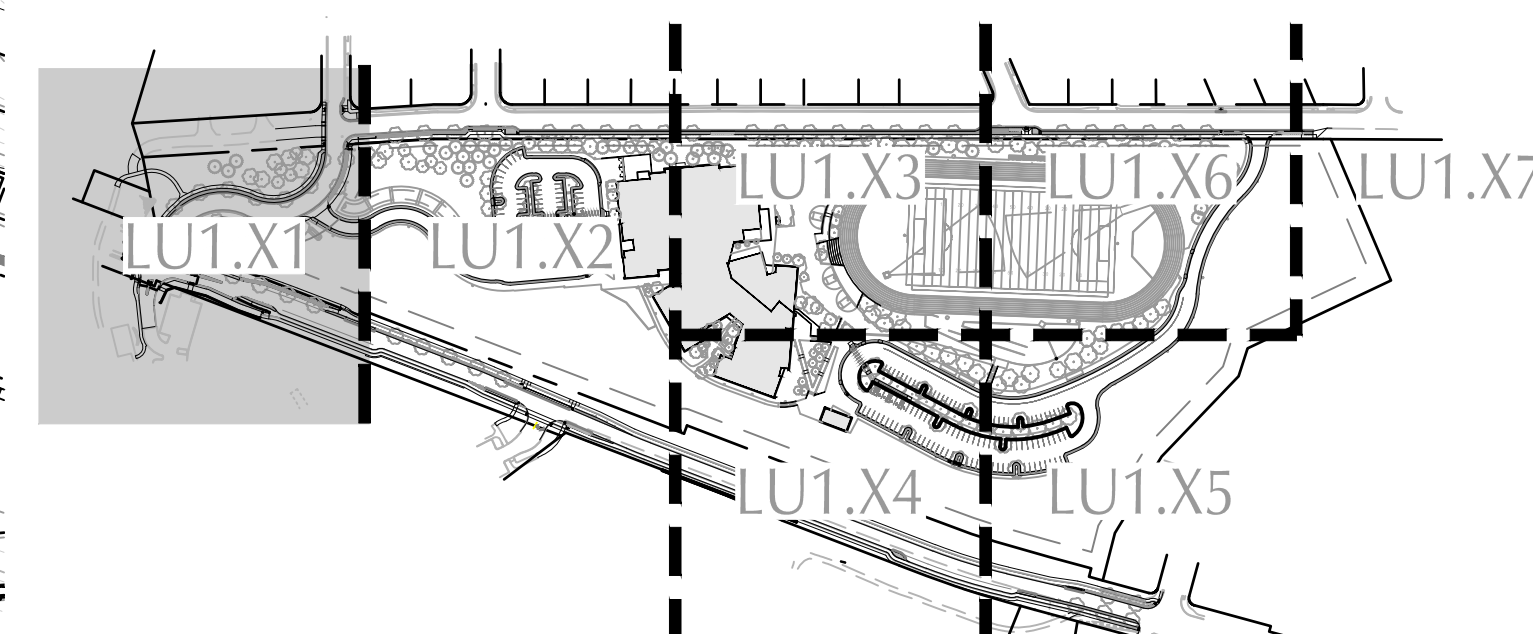

CLIENT
West Linn-Wilsonville
School District

22210 SW Stafford Rd, Tualatin, OR 97062

COPYRIGHT
This drawing has been prepared solely for the intended use, thus any reproduction or distribution for any purpose other than authorized by IBI Group is forbidden.
Written dimensions shall have precedence over scaled dimensions. Contractors shall verify and be responsible for all dimensions and conditions on the job, and IBI Group shall be informed of any variations from the dimensions and conditions shown on the drawing. Shop drawings shall be submitted to IBI Group for general confirmation before proceeding with fabrication.

PLEASE CHOOSE LEGAL ENTITY
is a member of the BM Group of companies

| ISSUES | | |
|--------|-------------|------------|
| No. | DESCRIPTION | DATE |
| 1 | LAND USE | 2021-03-17 |

KEYPLAN

CONSULTANTS



111 SW Fifth Ave., Suite 2600
Portland, OR 97204
O: 503.542.3860
F: 503.274.4681
www.kpff.com

SEAL



IBI GROUP
907 SW Harvey Milk Street
Portland, OR 97205, USA
tel 503 226 6950 fax 503 273 9192
ibigroup-edpnw.com

| | |
|---------|-------------------------------|
| PROJECT | New Athey Creek Middle School |
|---------|-------------------------------|

945 Dollar Street
West Linn, OR 97068

PROJECT NO:
134739

DRAWN BY:

DRAWN BY:
yy

| |
|------------|
| XX |
| PROJECT MC |


| | |
|---------------------------|----------|
| Designer | Approver |
| SHEET TITLE | |
| GRADING AND DRAINAGE PLAN | |

SHEET NUMBER
LU

ISSUE
A



CUP-21-02 Staff Report Exhibit PC-1
Page 1296 of 1498

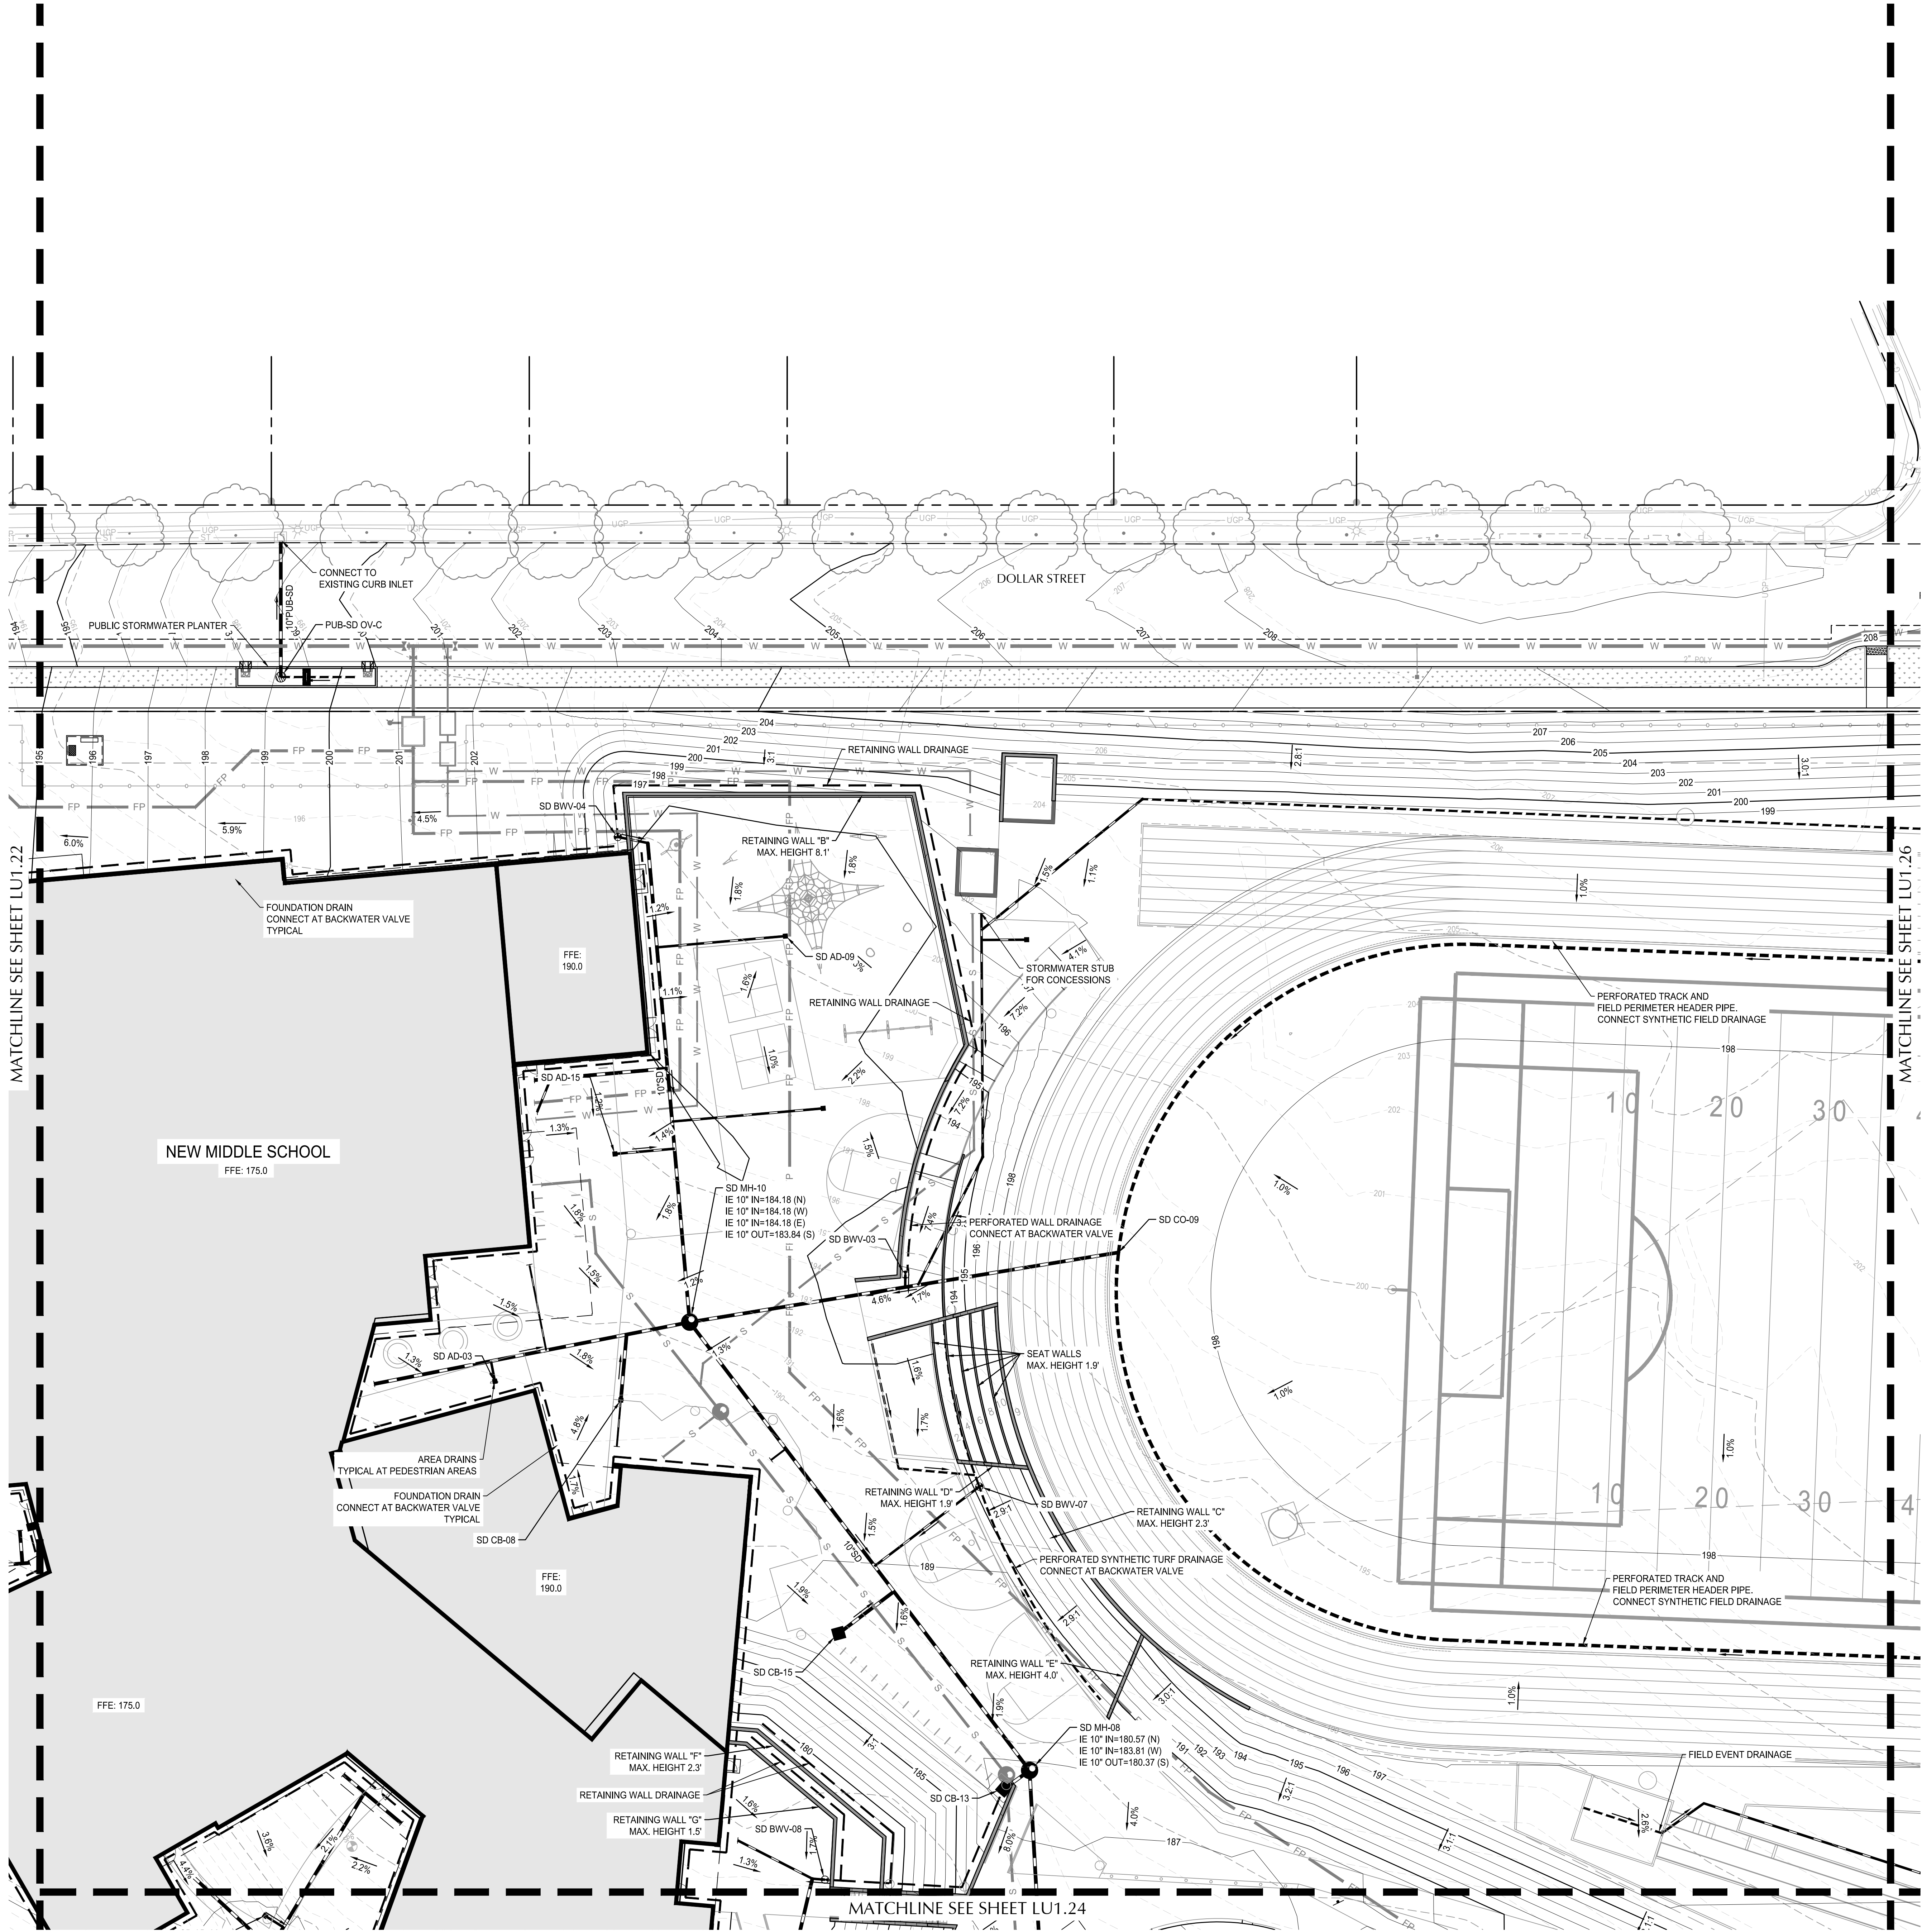


| GRADING LABEL LEGEND | |
|----------------------|--|
| CALLOUT | DESCRIPTION |
| X.X% | GRADING SLOPE AND DIRECTION (DOWNHILL) |

| SHEET LEGEND | |
|--------------|-------------------------|
| | DRAINAGE FLOW DIRECTION |
| | GRADE BREAK |
| | EX. CONTOUR MINOR |
| | EX. CONTOUR MAJOR |
| | CONTOUR MINOR (FG) |
| | CONTOUR MAJOR (FG) |
| | CONVEYANCE SWALE |

| UTILITY LABEL LEGEND | |
|---|-----------------------------------|
| STRUCTURE LABEL | |
| UTILITY TYPE (SD=STORM DRAINAGE PUB=SD-PUBLIC STORM DRAINAGE) | |
| STRUCTURE TYPE CALLOUT | |
| ID NUMBER (WHERE APPLICABLE) | |
| XX XX-XX IE IN = XX.X IE OUT = XX.X | STRUCTURE INFO (WHERE APPLICABLE) |

| PIPE LABEL | |
|----------------|--|
| UTILITY SIZE | |
| NETWORK NAME | |
| XX" XX | |
| FLOW DIRECTION | |

| STRUCTURE TYPE | |
|----------------|-------------------------|
| CALLOUT | DESCRIPTION |
| AD | AREA DRAIN |
| BWV | BACKWATER VALVE |
| CB | CATCH BASIN |
| CI | CURB INLET |
| CO | CLEANOUT TO GRADE |
| DI | DITCH INLET |
| FTMH | FLAT TOP MANHOLE |
| GI | GUTTER INLET |
| MH | MANHOLE |
| OF | OUTFALL |
| OV | OVERFLOW INLET |
| SFCB | STORMFILTER CATCH BASIN |
| WQMH | WATER QUALITY MANHOLE |

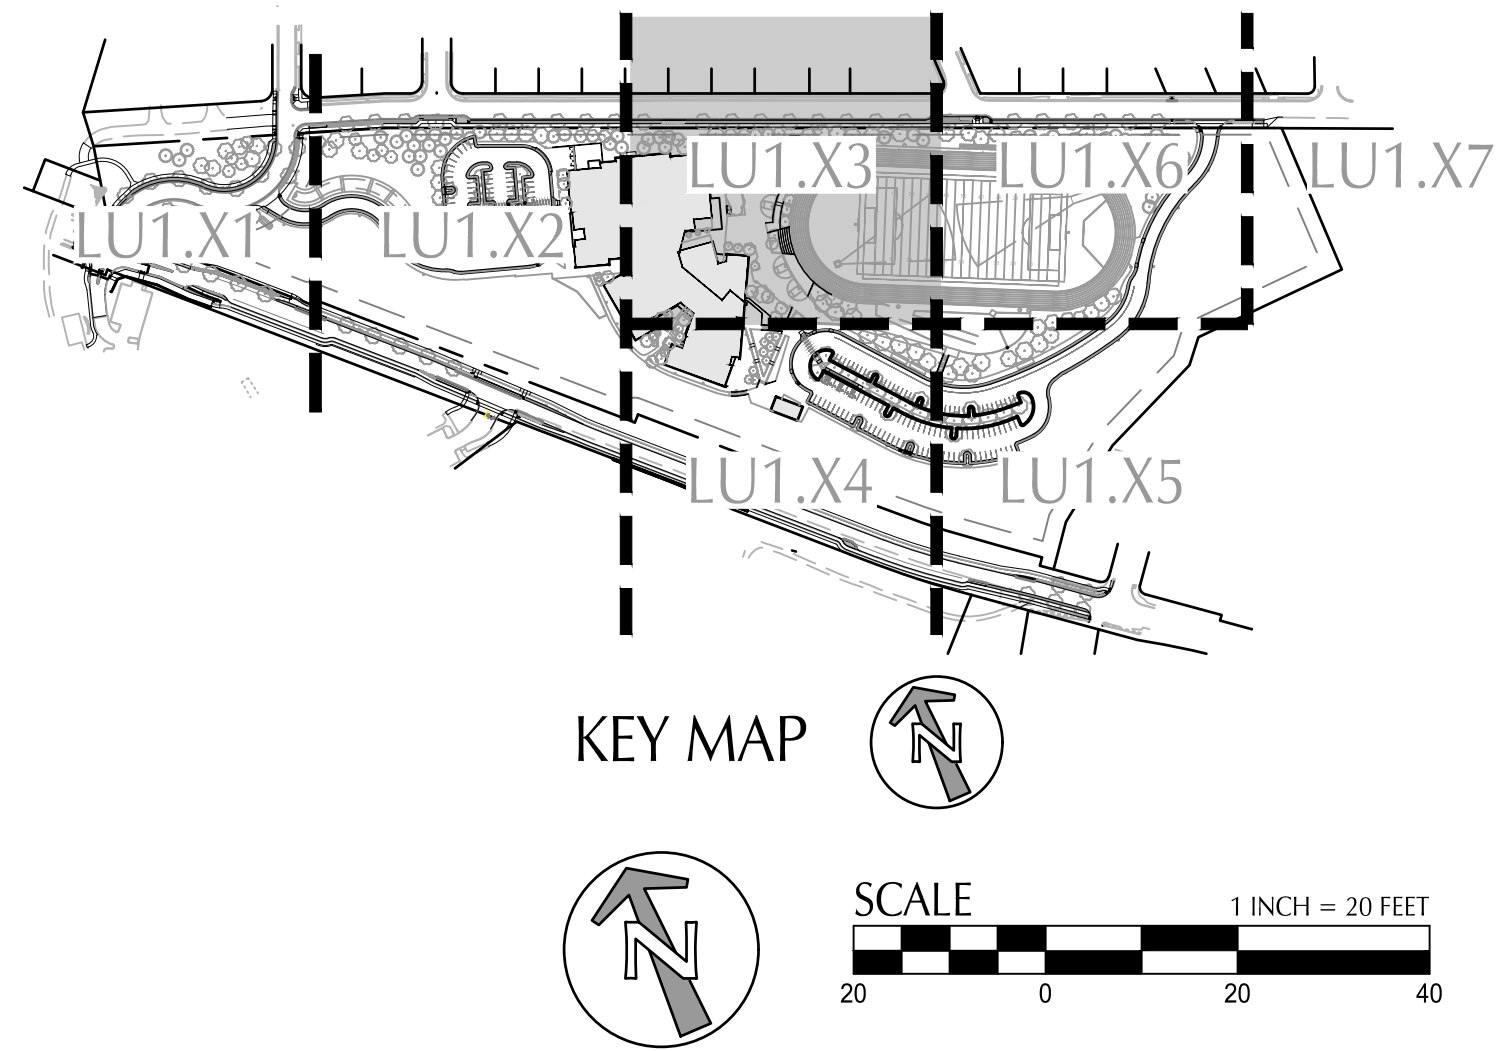

CLIENT

West Linn-Wilsonville School District

22210 SW Stafford Rd, Tualatin, OR 97062

COPYRIGHT

This drawing has been prepared solely for the intended use, thus any reproduction or distribution for any purpose other than authorized by BSI Group is forbidden. Written dimensions shall have precedence over scaled dimensions. Contractors shall verify and be responsible for all dimensions and conditions on the job, and BSI Group shall not be liable for any variations from the dimensions and conditions shown on the drawing. Shop drawings shall be submitted to BSI Group for general confirmation before proceeding with fabrication.

PLEASE CHOOSE LEGAL ENTITY

is a member of the BSI Group of companies

| ISSUES | | |
|--------|-------------|------------|
| No. | DESCRIPTION | DATE |
| 1 | LAND USE | 2021-03-17 |

KEYPLAN

CONSULTANTS

111 SW Fifth Ave., Suite 2600
Portland, OR 97204
P: 503.542.3660
F: 503.274.4681
www.kpff.com

SEAL

IBI GROUP
907 SW Harvey Milk Street
Portland, OR 97205, USA
tel 503 226 6950 fax 503 273 9192
ibi@group-eds.com

PROJECT

New Athey Creek Middle School

945 Dollar Street
West Linn, OR 97068

PROJECT NO:

124738

DRAWN BY:

XX

CHECKED BY:

Checker

PROJECT MGR:

Designer


APPROVED BY:

Approver

SHEET TITLE


GRADING AND DRAINAGE PLAN

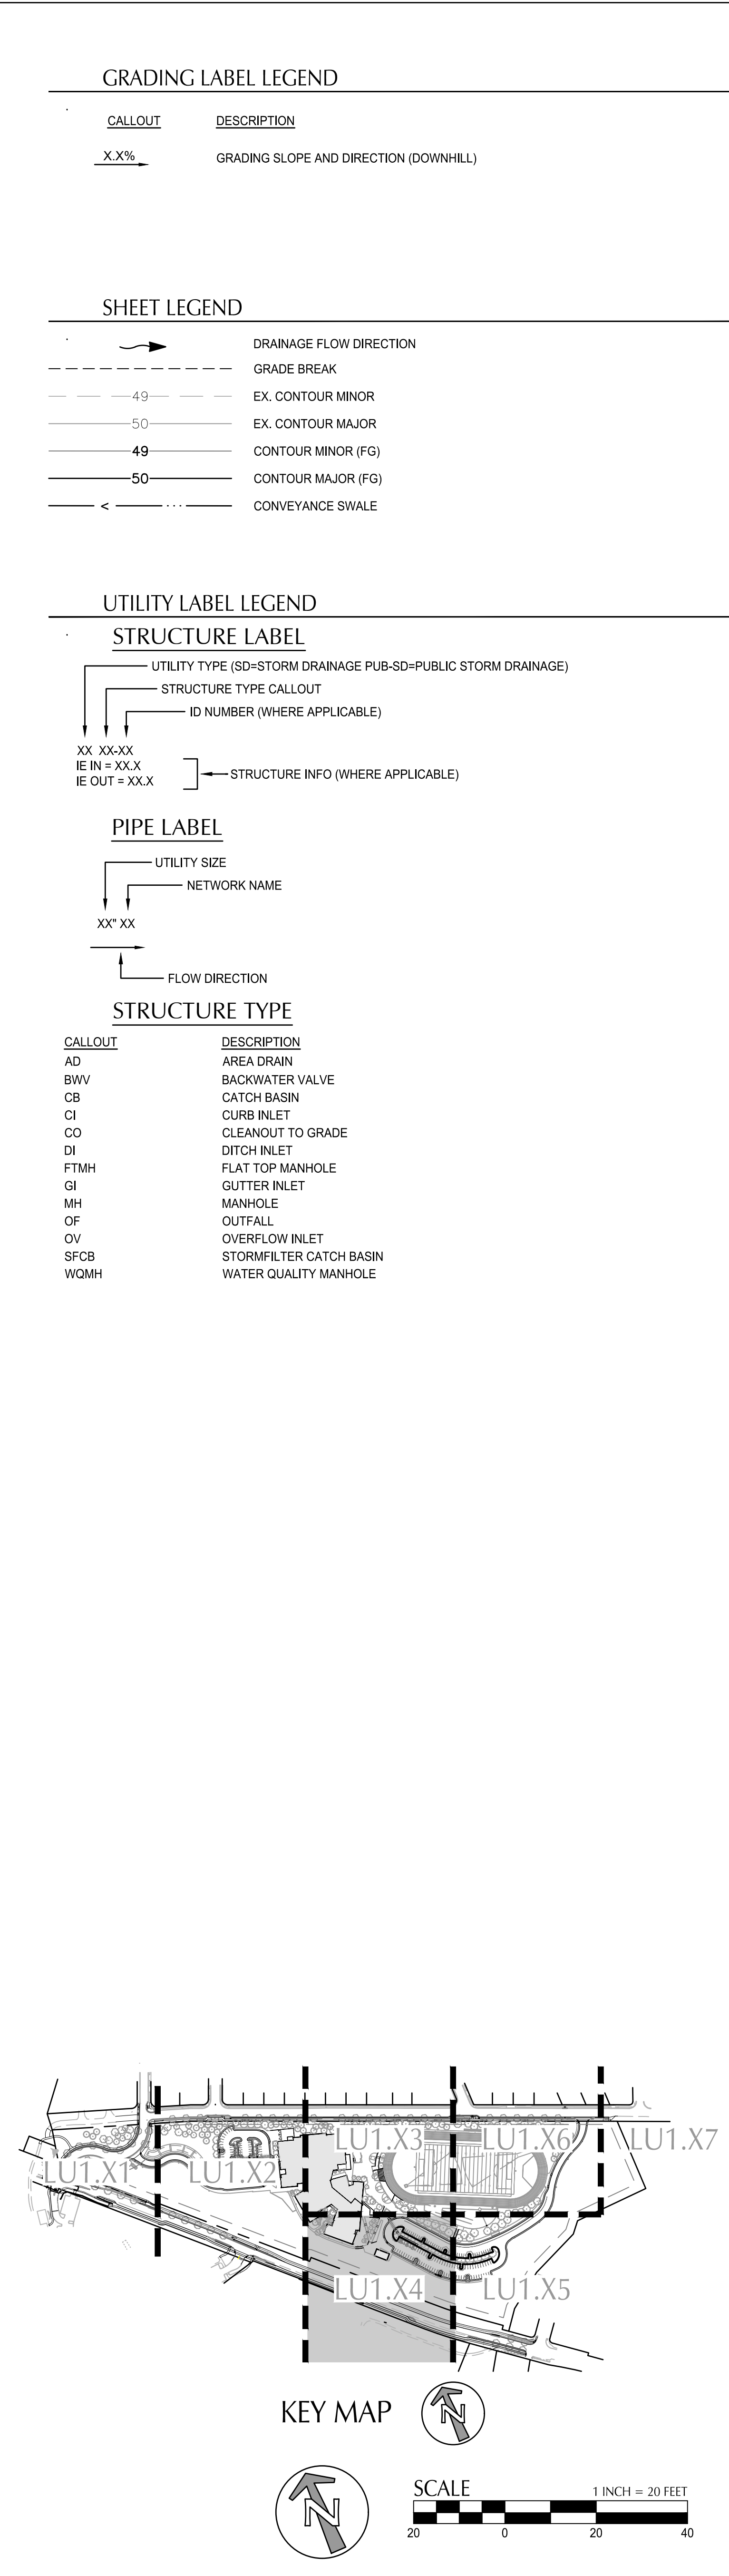


| | |
|--------------|-------|
| SHEET NUMBER | ISSUE |
| LU1.23 | A |



| | |
|----------|---|
| RE CHECK | BIM 380-1124738 - Wilcox New Middle School B2020/124738 Wilcox New Middle School B2020/ |
|----------|---|

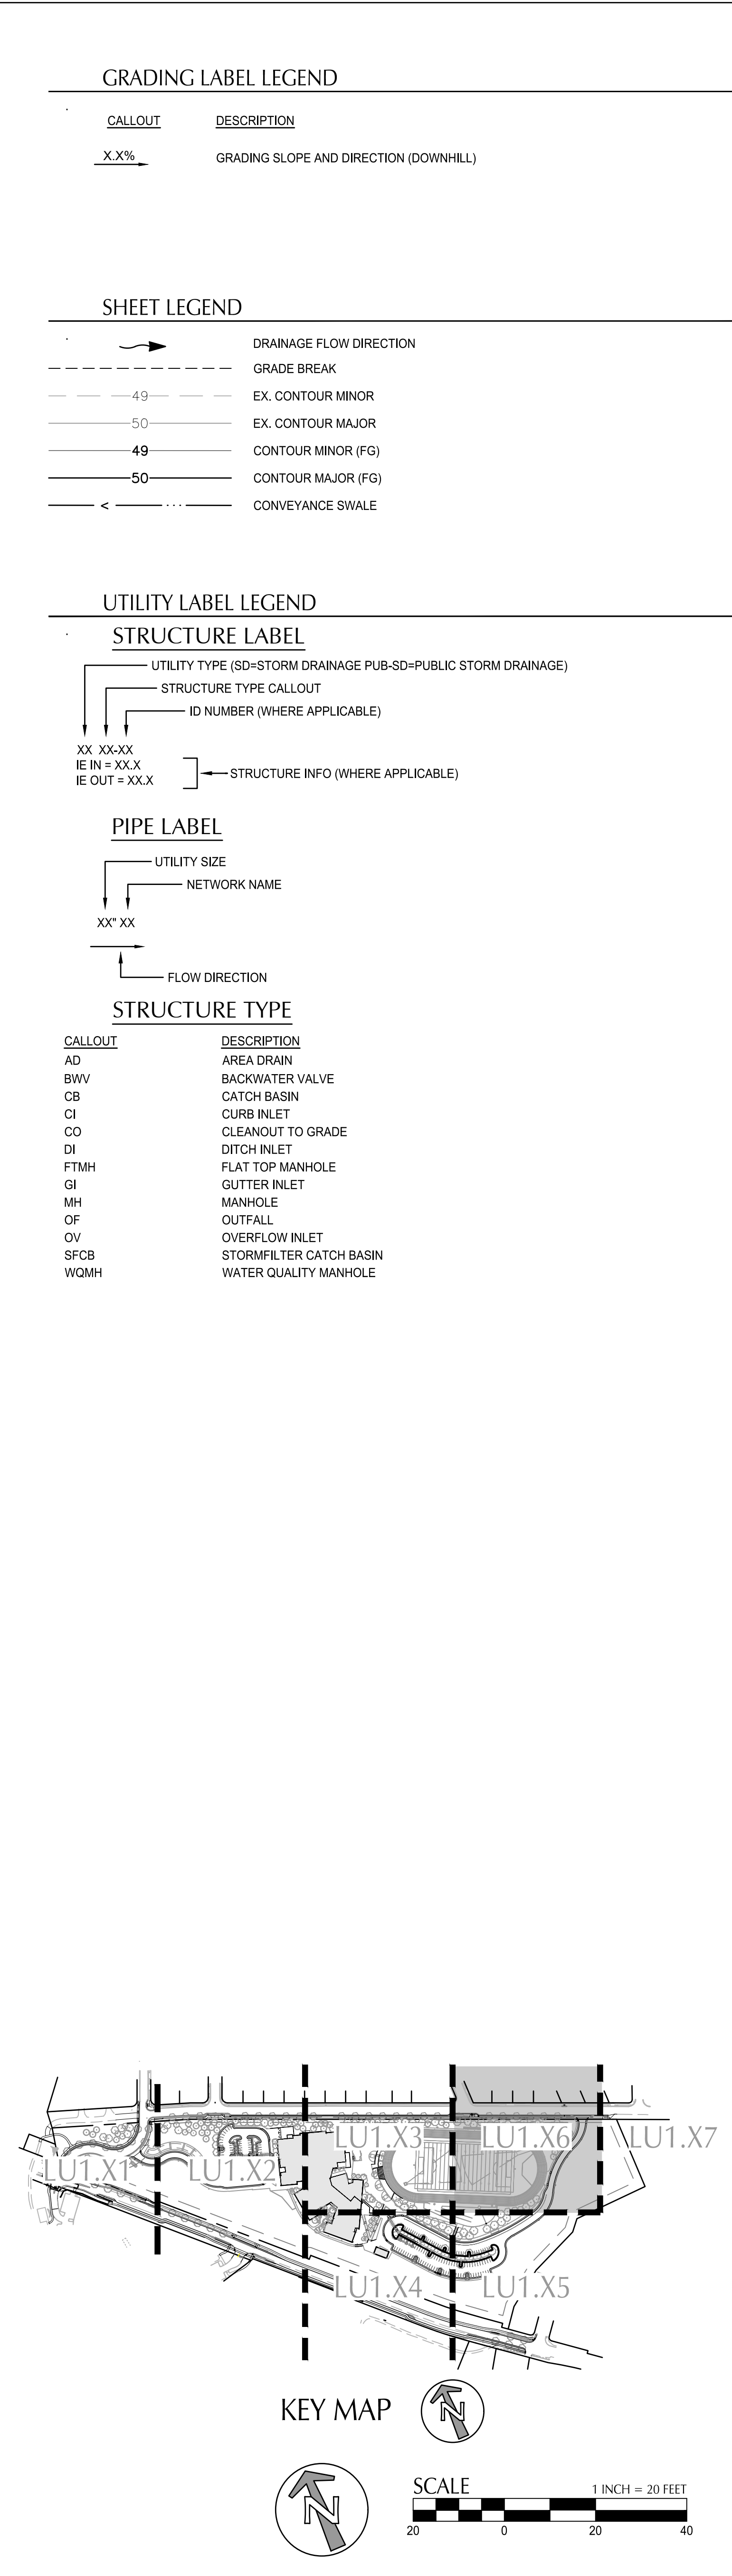




| | | |
|---|--------------------------|------------|
| CLIENT | | |
| West Linn-Wilsonville School District | | |
|  | | |
| 22210 SW Stafford Rd, Tualatin, OR 97062 | | |
| COPYRIGHT | | |
| This drawing has been prepared solely for the intended use. Thus any reproduction or distribution for any purpose other than authorized by IBI Group is forbidden. Written dimensions shall have precedence over scaled dimensions. Constructors shall verify and be responsible for all dimensions and conditions on the job, and IBI Group shall be relieved of any liabilities from the dimensions and conditions shown on the drawing. Group drawings shall be submitted to IBI Group for general conformance before proceeding with fabrication. | | |
| PLEASE CHOOSE LEGAL ENTITY Is a member of the IBI Group of companies. | | |
| ISSUES | | |
| No. | DESCRIPTION | DATE |
| 1 | LAND USE | 2021-03-17 |
| | | |
| KEYPLAN | | |
| | | |
| CONSULTANTS | | |
|  | | |
| 111 SW Fifth Ave., Suite 2600 Portland, OR 97204 O: 503.542.5860 F: 503.274.4681 www.kpff.com | | |
| | | |
| SEAL | | |
| | | |
|  | | |
| IBI GROUP 907 SW Harvey Milk Street Portland, OR 97205, USA tel 503 226 6950 fax 503 273 9192 ibigroup-edpww.com | | |
| PROJECT | | |
| New Athey Creek Middle School | | |
| 945 Dollar Street West Linn, OR 97068 | | |
| PROJECT NO: 124738 | | |
| DRAWN BY: XX | CHECKED BY: Checker | |
| PROJECT MGR: Designer | APPROVED BY: Approver | |
| SHEET TITLE | | |
| GRADING AND DRAINAGE PLAN | | |
| SHEET NUMBER | | ISSUE |
| LU1.26 | | A |



| <u>CALLOUT</u> | <u>DESCRIPTION</u> |
|----------------|-------------------------|
| AD | AREA DRAIN |
| BWV | BACKWATER VALVE |
| CB | CATCH BASIN |
| CI | CURB INLET |
| CO | CLEANOUT TO GRADE |
| DI | DITCH INLET |
| FTMH | FLAT TOP MANHOLE |
| GI | GUTTER INLET |
| MH | MANHOLE |
| OF | OUTFALL |
| OY | OVERFLOW INLET |
| SFCB | STORMFILTER CATCH BASIN |
| WQMH | WATER QUALITY MANHOLE |

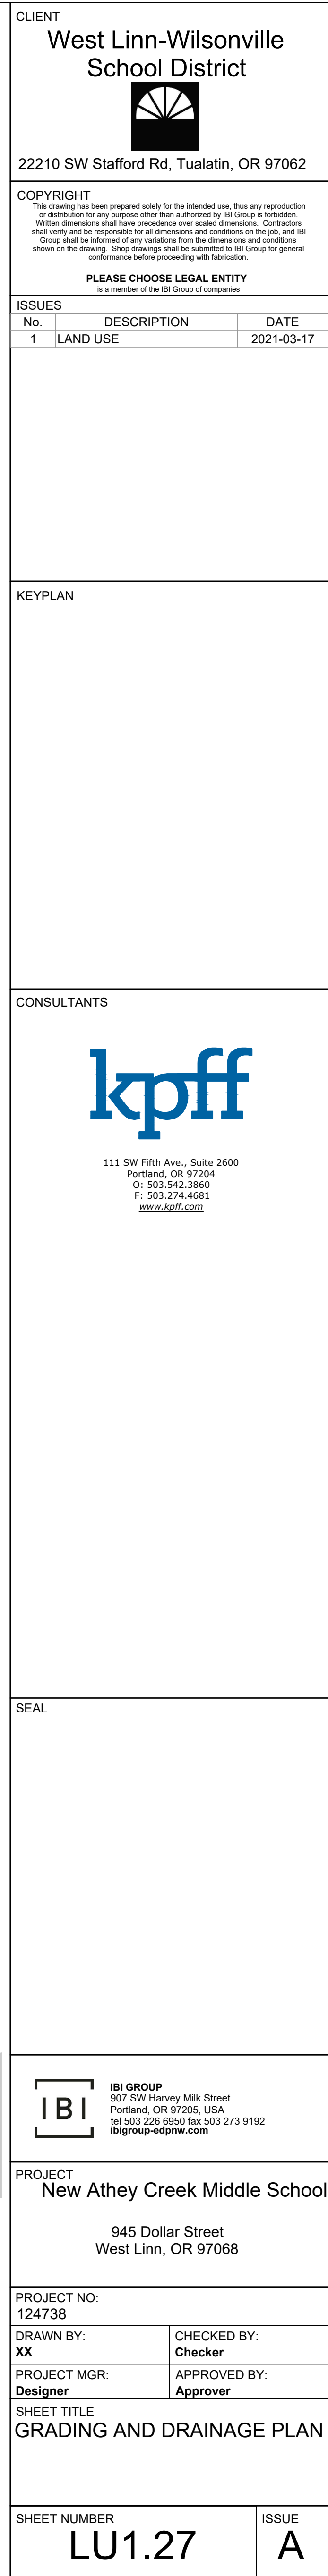



COPYRIGHT
This drawing has been prepared solely for the intended use, thus any reproduction or distribution for any purpose other than authorized by IBI Group is forbidden.
Written dimensions shall have precedence over scaled dimensions. Contractors shall verify and be responsible for all dimensions and conditions on the job, and IBI Group shall be relieved of any liability from the dimensions and conditions shown on the drawing. Shop drawings shall be submitted to IBI Group for general confirmation before proceeding with fabrication.

PLEASE CHOOSE LEGAL ENTITY
is a member of the IRI Group of companies

KEYPLAN

CONSULTANTS



SEAL



945 Dollar Street
West Linn, OR 97068

PROJECT NO:
124738

DRAWN BY:

CHECKED BY:

PROJECT MGR

APPROVED BY _____

SHEET TITLE

OVERALL UTILITY PLAN

SHEET NUMBER

LU1.30

ISSUE

A


File: N:\cp\2020\2000067-Dollar-Street-MISCAD\PLOT\U2000067-LU130-OVERALL-UTIL.dwg TAB:LU1.30
Plotted: 3/16/21 at 4:50pm By: mmanner
2020-07-17 12:31:12 PM



SEAL



| CALLOUT | DESCRIPTION |
|---------|------------------------------------|
| CO | CLEANOUT TO GRADE |
| OCVA | DOUBLE CHECK VALVE ASSEMBLY |
| ODCV | DOUBLE DETECTOR CHECK VALVE |
| DC | FIRE DEPARTMENT CONNECTION |
| FM | FIRE HYDRANT |
| GM | GAS METER |
| GV | GATE VALVE |
| HB | HORIZONTAL BEND |
| MH | MANHOLE |
| PV | POST INDICATOR VALVE |
| RPBA | REDUCED PRESSURE BACKFLOW ASSEMBLY |
| STUB | STUB |
| TEE | TEE CONNECTION |
| VB | VERTICAL BEND |
| WM | WATER METER |

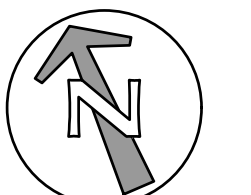

SCALE

1 INCH = 20 FEET



COPYRIGHT
This drawing has been prepared solely for the intended use, thus any reproduction or distribution for any purpose other than authorized by IBI Group is forbidden.
Written dimensions shall have precedence over scaled dimensions. Contractors shall verify and be responsible for all dimensions and conditions on the job, and IBI Group shall be informed of any variations from the dimensions and conditions shown on the drawing. Shop drawings shall be submitted to IBI Group for general confirmation before proceeding with fabrication.

| PLEASE CHOOSE LEGAL ENTITY | | |
|---|-------------|-----------|
| is a member of the 888 Group of companies | | |
| ISSUES | | |
| No. | DESCRIPTION | DATE |
| 1 | LAND USE | 2021-03-1 |

KEYPLAN

CONSULTANTS



SEAL



PROJECT
New Athey Creek Middle School

945 Dollar Street
West Linn, OR 97068

PROJECT NO
124738

DRAWN BY:
XX

PROJECT MC
Designer

SHEET TITLE UTILITY PLAN

SHEET NUMBER


ISSUE

BIM 360://124738 - WLWV New Middle School R2020/124738_WLVVNewMiddleSchool_R20.rvt



KEY MAP

| | |
|-------------|--|
| SCALE CHECK | BIM 360://124738 - WLWV New Middle School R2020/124738 WLWVNewMiddleSchool_R20.rvt |
|-------------|--|

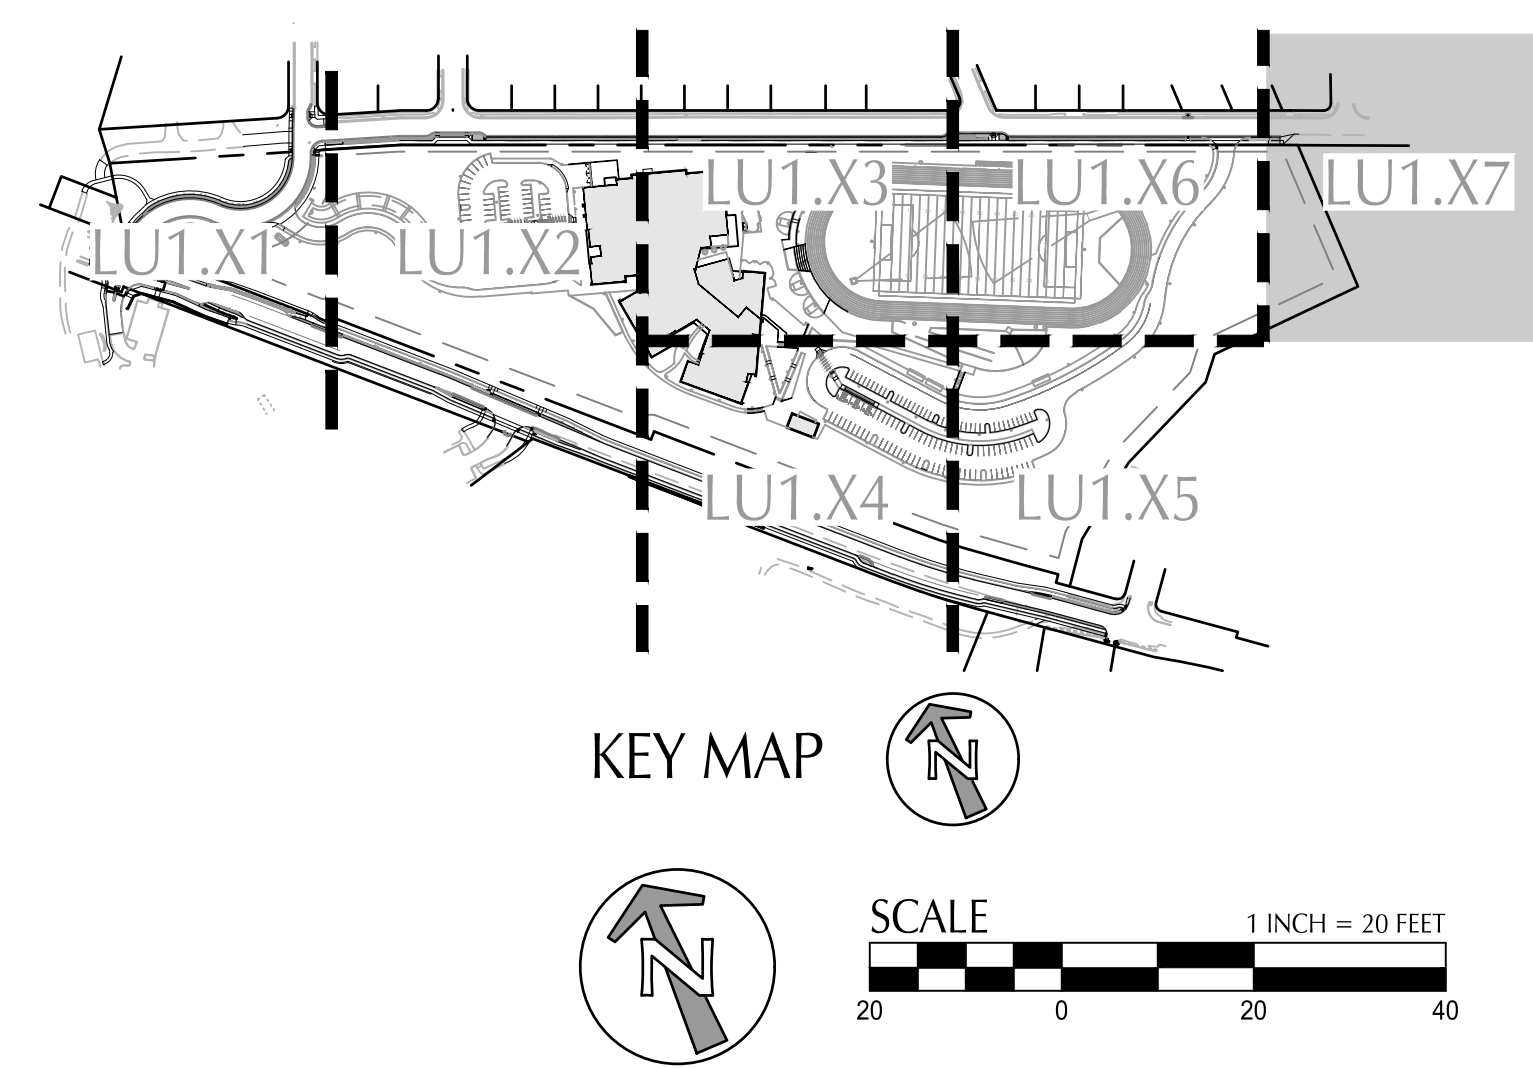

CUP-21-02 Staff Report Exhibit PC-1
Page 1309 of 1498